
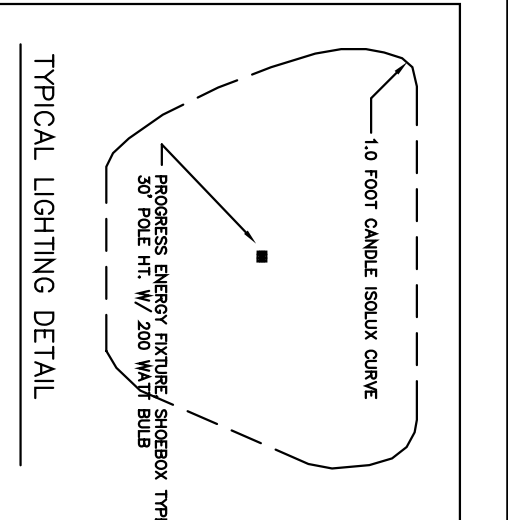
 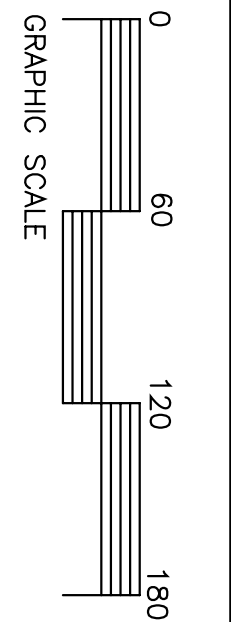

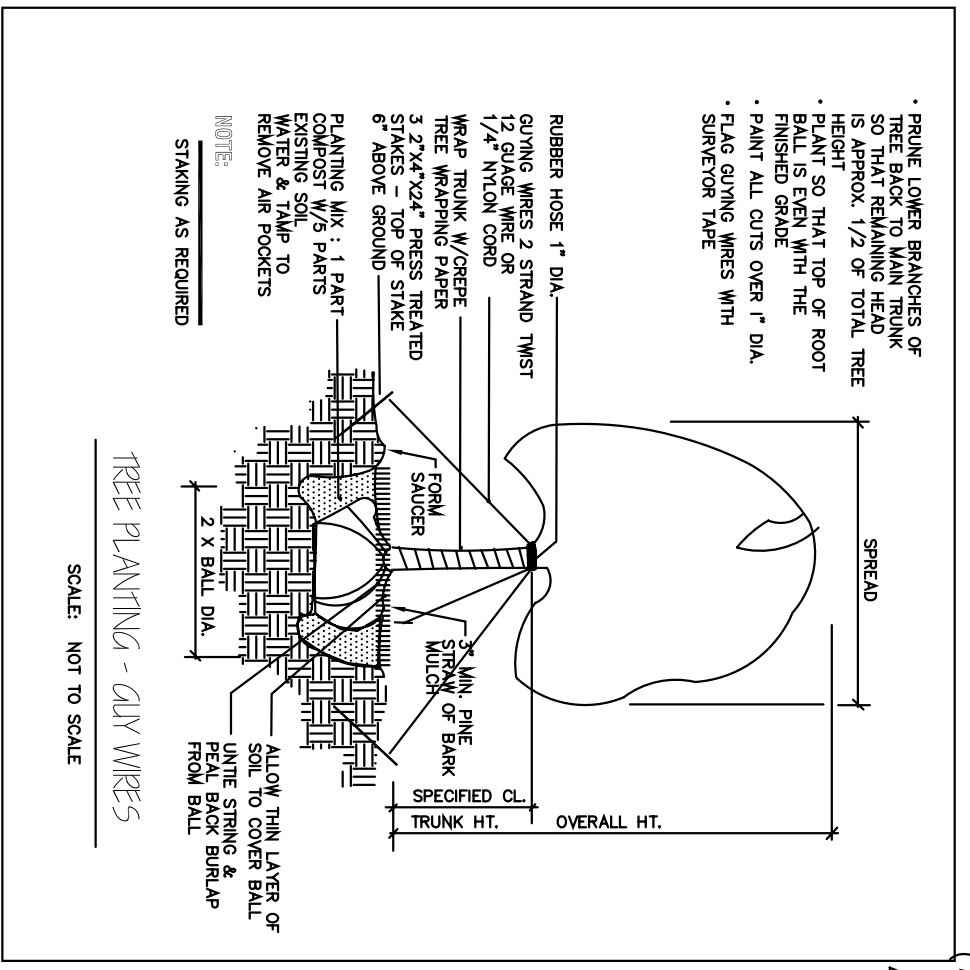


- LEGEND**
- Existing Iron Pipe
 - Iron Pipe Set
 - Existing Concrete Monument
 - Concrete Monument Set
 - Parker-Kalon Nail Set
 - ▲ 60D Nail Found
 - ▲ 60D Nail Set
 - Existing Railroad Spike
 - Railroad Spike Set
 - Mathematical Point (Not Set)
 - Math Nail Set
 - Math Nail Set
 - Utility Pole
 - Sanitary Sewer Easement
 - Street Address (Typical)
 - TL - Total
 - R/W - Right of Way

LINE DATA TABLE


LINE	BEARING	LENGTH
L1	S 71°52'20" W	12.30'
L2	S 83°35'41" W	56.17'
L3	N 89°03'40" W	61.84'

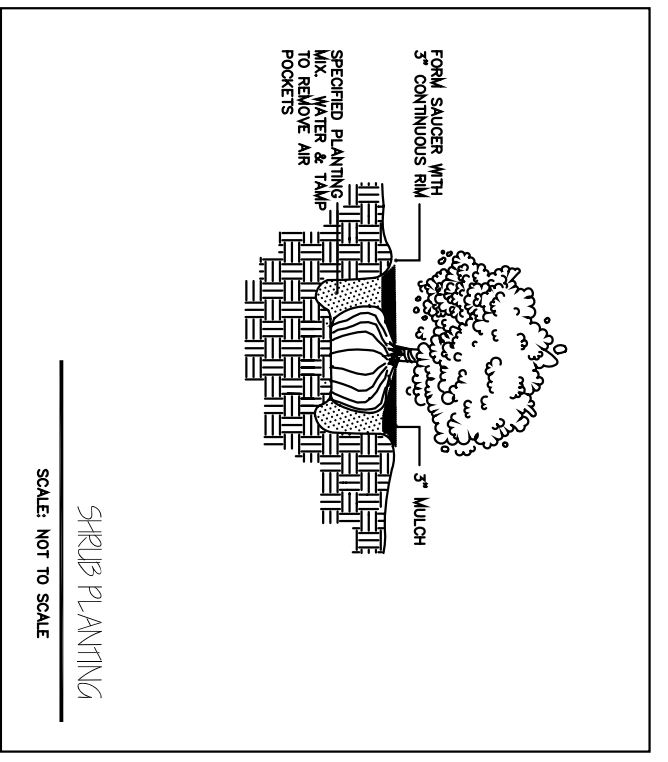

- PLANTING NOTES & SPECIFICATIONS**
- ALL TREES AND SHRUBS HAVE BEEN LOCATED WITH RESPECT TO PROPOSED OR EXISTING FEATURES.
 - VERIFICATION OF TOTAL QUANTITIES AS SHOWN IN THE PLANT LIST SHALL BE THE RESPONSIBILITY OF THE CONTRACTOR.
 - ALL TREES, SHRUBS AND OTHER PLANTS SHALL CONFORM TO ACCEPTED STANDARDS ESTABLISHED BY THE AMERICAN ASSOCIATION OF NURSERYMEN UNLESS OTHERWISE SPECIFIED.
 - PLANTING - TREE BRANCHES AND FOLIAGE OF REDWOOD TREES (NOT ALL END TREES) BY 1/3.
 - ALL PLANTS SHALL BEAT THE SAME RELATIONSHIP TO FINISHED GRADE AS IT BORE TO PREVIOUS EXISTING GRADE. PLANT ALL AXELAS AND PROPOSED WITH 1/3 OF ROOT BALL ABOVE.
 - ALL ROOT BALLS REMOVED FROM CONTAINERS SHALL BE SCARIFIED PRIOR TO BACKFILLING.
 - ALL ABOVE GROUND UTILITY DEVICES TO BE SCARIFIED WITH NEEDLEPOINT HOLES OR EQUAL EQUIVALENT BY THE LANDSCAPE CONTRACTOR.

PLANT LIST

SYMBOL	BOTANICAL NAME	COMMON NAME	SIZE	QUANTITY	REMARKS
RL	ACEA RUBRA 'RED SUNSET'	RED SUNSET RED MAJALE	2 1/2" CAL.	23	10' MIN. HT. B. & B.
RL	LAGESTROBIA NODA CAYAMBA	CAYAMA GARDEN WARTLE	8" HT.	14	8' MIN. HT. B. & B.
RL	BETULA NUNGA	SWAMP BIRCH	11	10' MIN. HT. B. & B.	
RL	QUERCUS ACOTISMA	SWAMPY OAK	2 1/2" CAL.	11	10' MIN. HT. B. & B.
RL	LEX GRACIA 'GREENLEAF'	GREENLEAF AMERICAN HOLLY	8" HT.	28	8' MIN. HT. B. & B.
RL	ABELIA GRANDIFOLIA 'TOWARD COURCHER'	MAX LEAF LOGSTIMUL	5" HT.	79	5' MIN. HT. CONT.
RL	MORCA GIBBERNA	MORCA GIBBERNA	5" HT.	44	5' MIN. HT. CONT.
RL	LEX SPANNA 'NEEDLEPOINT'	NEEDLEPOINT CHINESE HOLLY	3" HT.	28	3' MIN. HT. CONT.

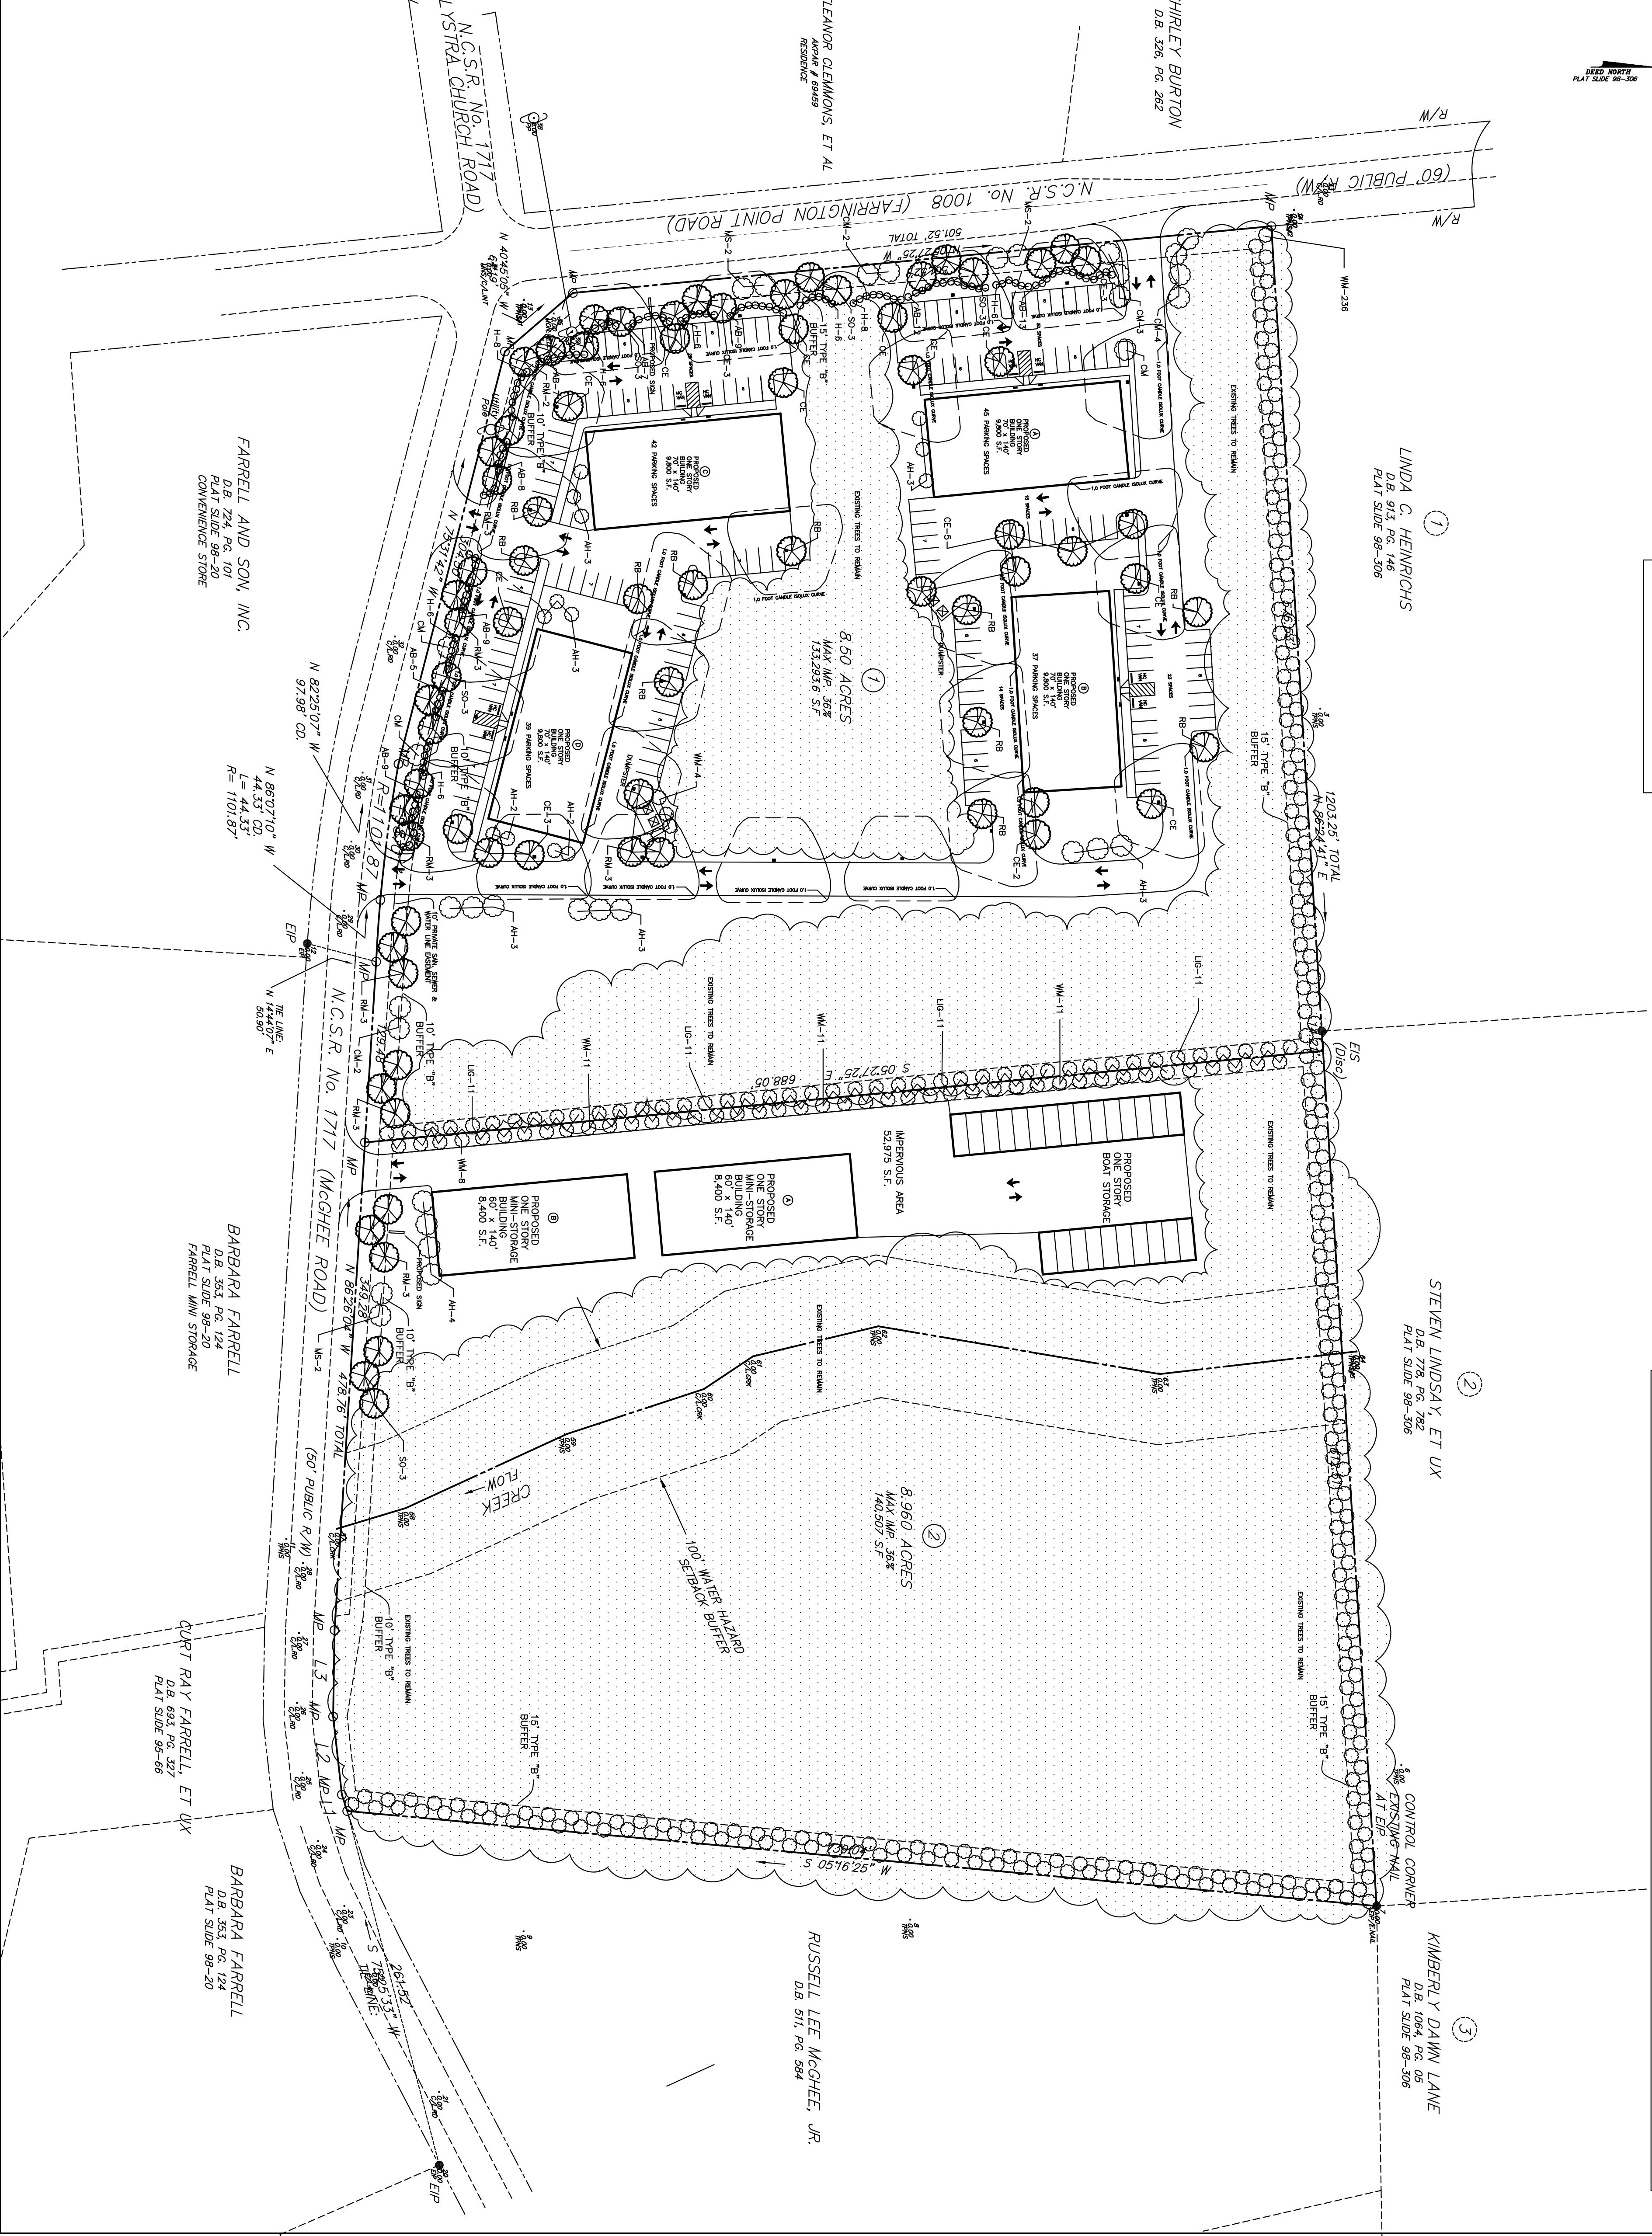

LANDSCAPE & LIGHTING PLAN

FARRELL PROPERTY

FARRINGTON & MCGHEE RD, CHATHAM CO.

BLAKELY DESIGN GROUP

Landscape Architecture Site Planning

700 Exposition Place, Suite 105, Raleigh, North Carolina 27615
 Telephone (919) 872-1888 Fax (919) 870-8752
 E-Mail taylor@blakelydesign.net

SHEET C-2

DATE: AUG. 14, 06
 SCALE: 1"=60'
 DRAWN: BTB
 JOB NO.:
 REVISIONS:

