


VICINITY MAP
NOT TO SCALE

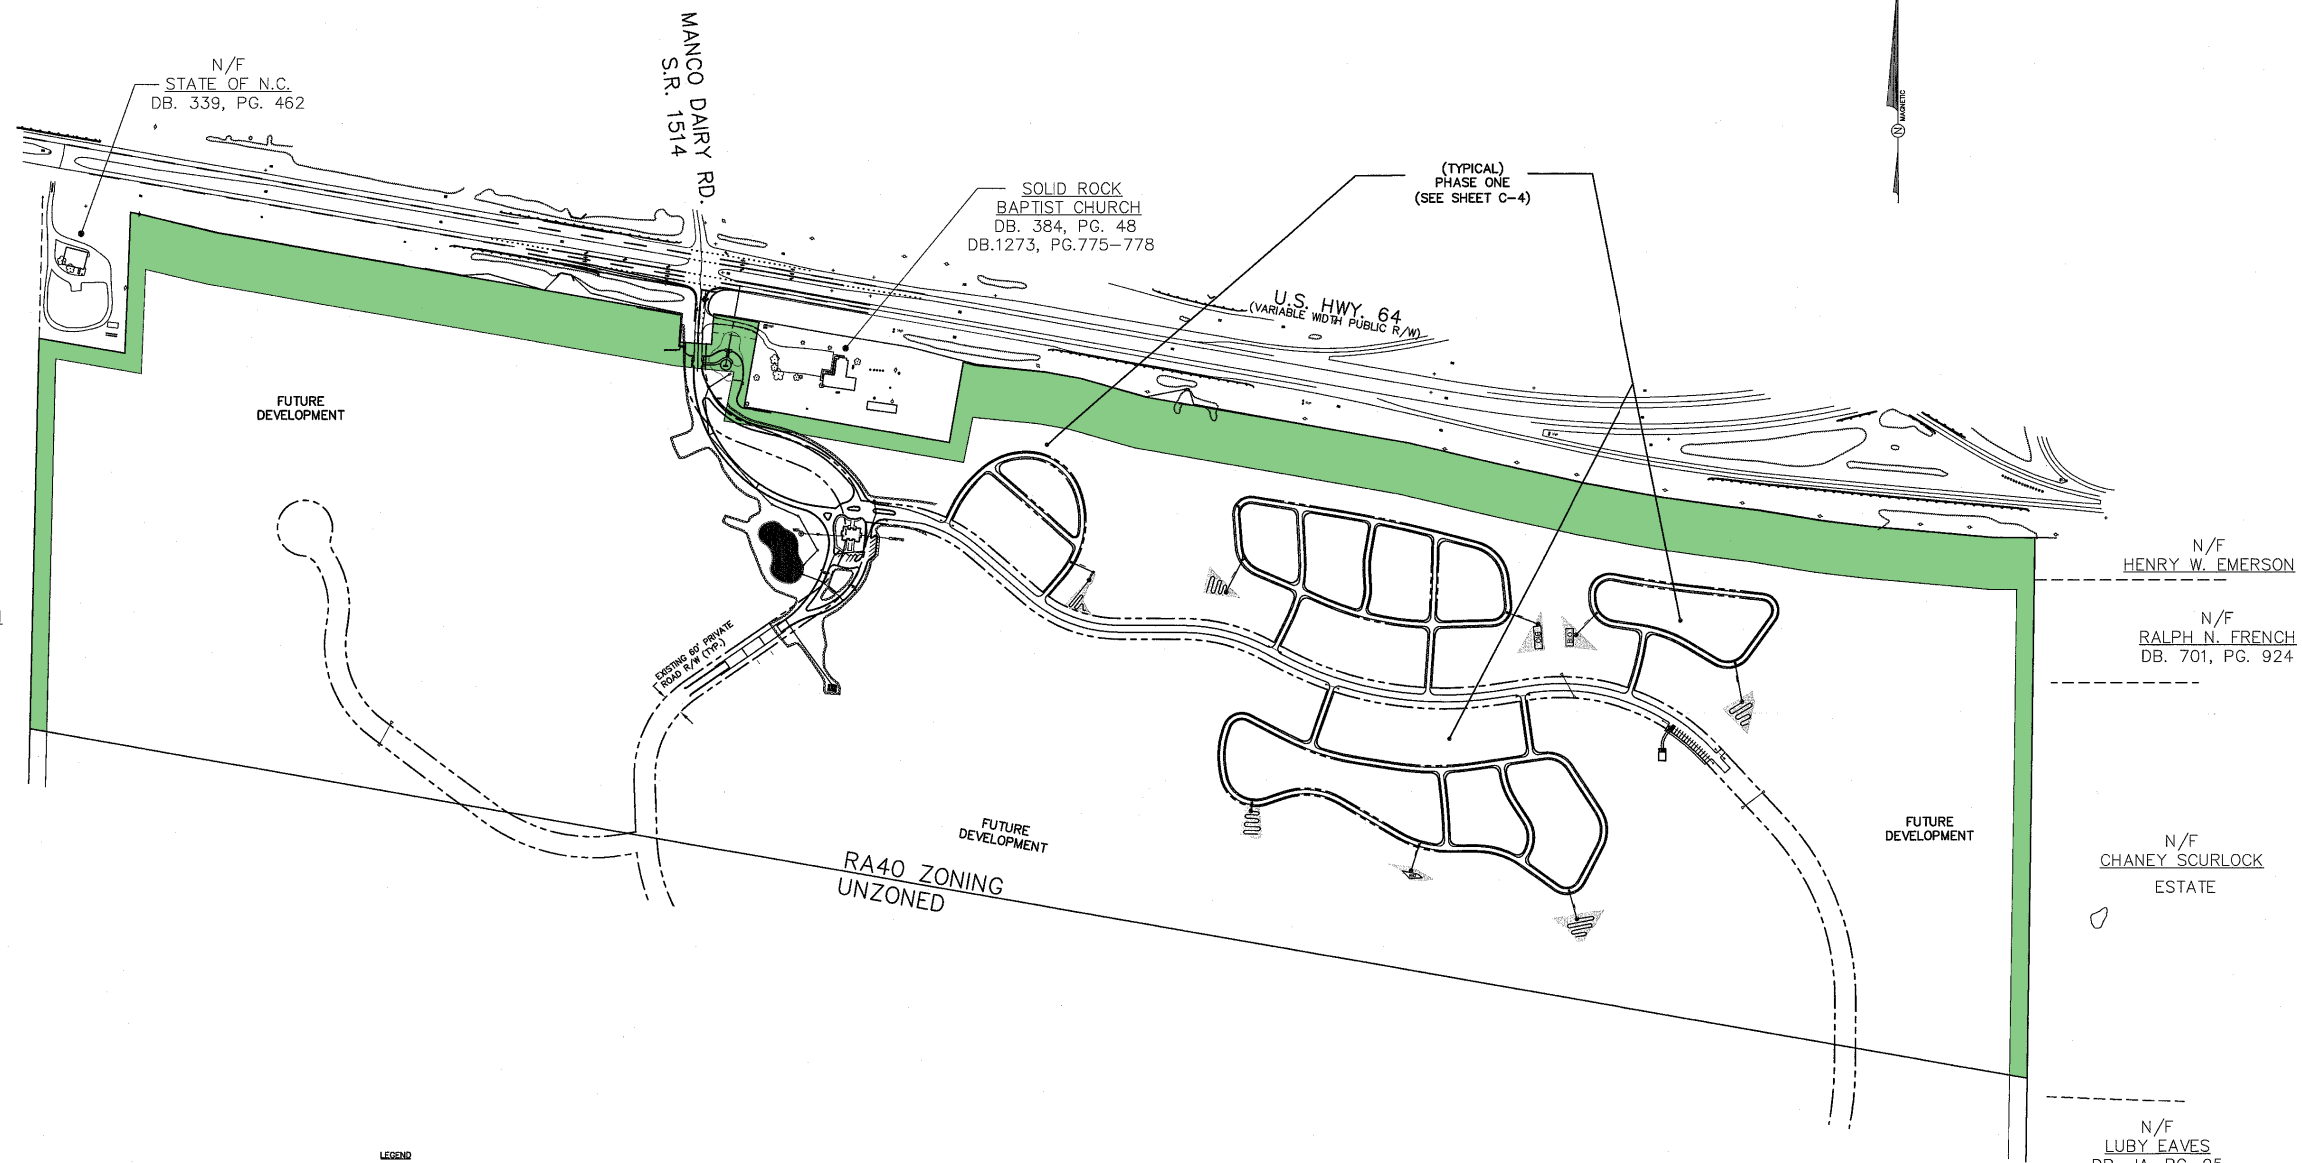

N/F
B.F. McLEOD, et al
DB. 732, PG. 846

N/F
STATE OF N.C.
DB. 339, PG. 462

MANCO DAIRY RD.
S.R. 1514

SOLID ROCK
BAPTIST CHURCH
DB. 384, PG. 48
DB.1273, PG.775-778

(TYPICAL)
PHASE ONE
(SEE SHEET C-4)

U.S. HWY 64
(VARIABLE WIDTH PUBLIC R/W)

N/F
HENRY W. EMERSON

N/F
RALPH N. FRENCH
DB. 701, PG. 924

N/F
CHANEY SCURLOCK
ESTATE

N/F
LUBY EAVES
DB. JA, PG. 95

- LEGEND**
- PROPOSED GRASS SWALE/WATER QUALITY AREAS AND ENERGY DISSIPATOR
 - PROPOSED STORM DRAINAGE SYSTEM
 - PROPOSED ENERGY DISSIPATOR AND SMALL BIO-RETENTION AREA
 - PROPOSED WATER SUPPLY WELL
 - PROPOSED SEPTIC DISPOSAL SYSTEM

- NOTES:**
1. NO WATERLINES ARE PROPOSED. ONE WELL IS PROPOSED AS SHOWN.
 2. NO SEWAGE COLLECTION SYSTEMS ARE PROPOSED. ONE SEPTIC DISPOSAL SYSTEM IS SHOWN.
 3. SITE WILL BE DEVELOPED WITH ROADWAYS, LANES, PATHS AND SMALL BUILDINGS AND WILL BE EQUAL TO OR LESS THAN 23% IMPERVIOUS, OVERALL.
 4. MAXIMUM IMPERVIOUS = 30%, OVERALL.



OWNER:
BELMEADE FARM, LLC
6208 FAYETTEVILLE RD., #104
DURHAM, N.C. 27713

ENGINEERS
PLANNERS
SURVEYORS
**PHILIP
POST
&
ASSOCIATES**
401 Providence Rd. # 200
Craigs Hill, NC 27514
403-2600 855-8882
Charlotte, NC
C38327-771

PRELIMINARY


SITE PLAN
BELMEADE FARM CEMETERY
CHATHAM COUNTY, N.C.
CENTER TOWNSHIP

SCALE: 1"=200'
DRAWN BY: JWP
CHECKED BY: JWP
DATE: 07/29/2009
PROJECT NO.: 210238
SHEET NO.: 04
This sheet is the property of Philip Post & Associates, Inc. It is to be used only for the project and site for which it was prepared. It is not to be used for any other project or site without the written consent of Philip Post & Associates, Inc.

REVISIONS

NO.	DATE	DESCRIPTION

SHEET C-1
OF 4

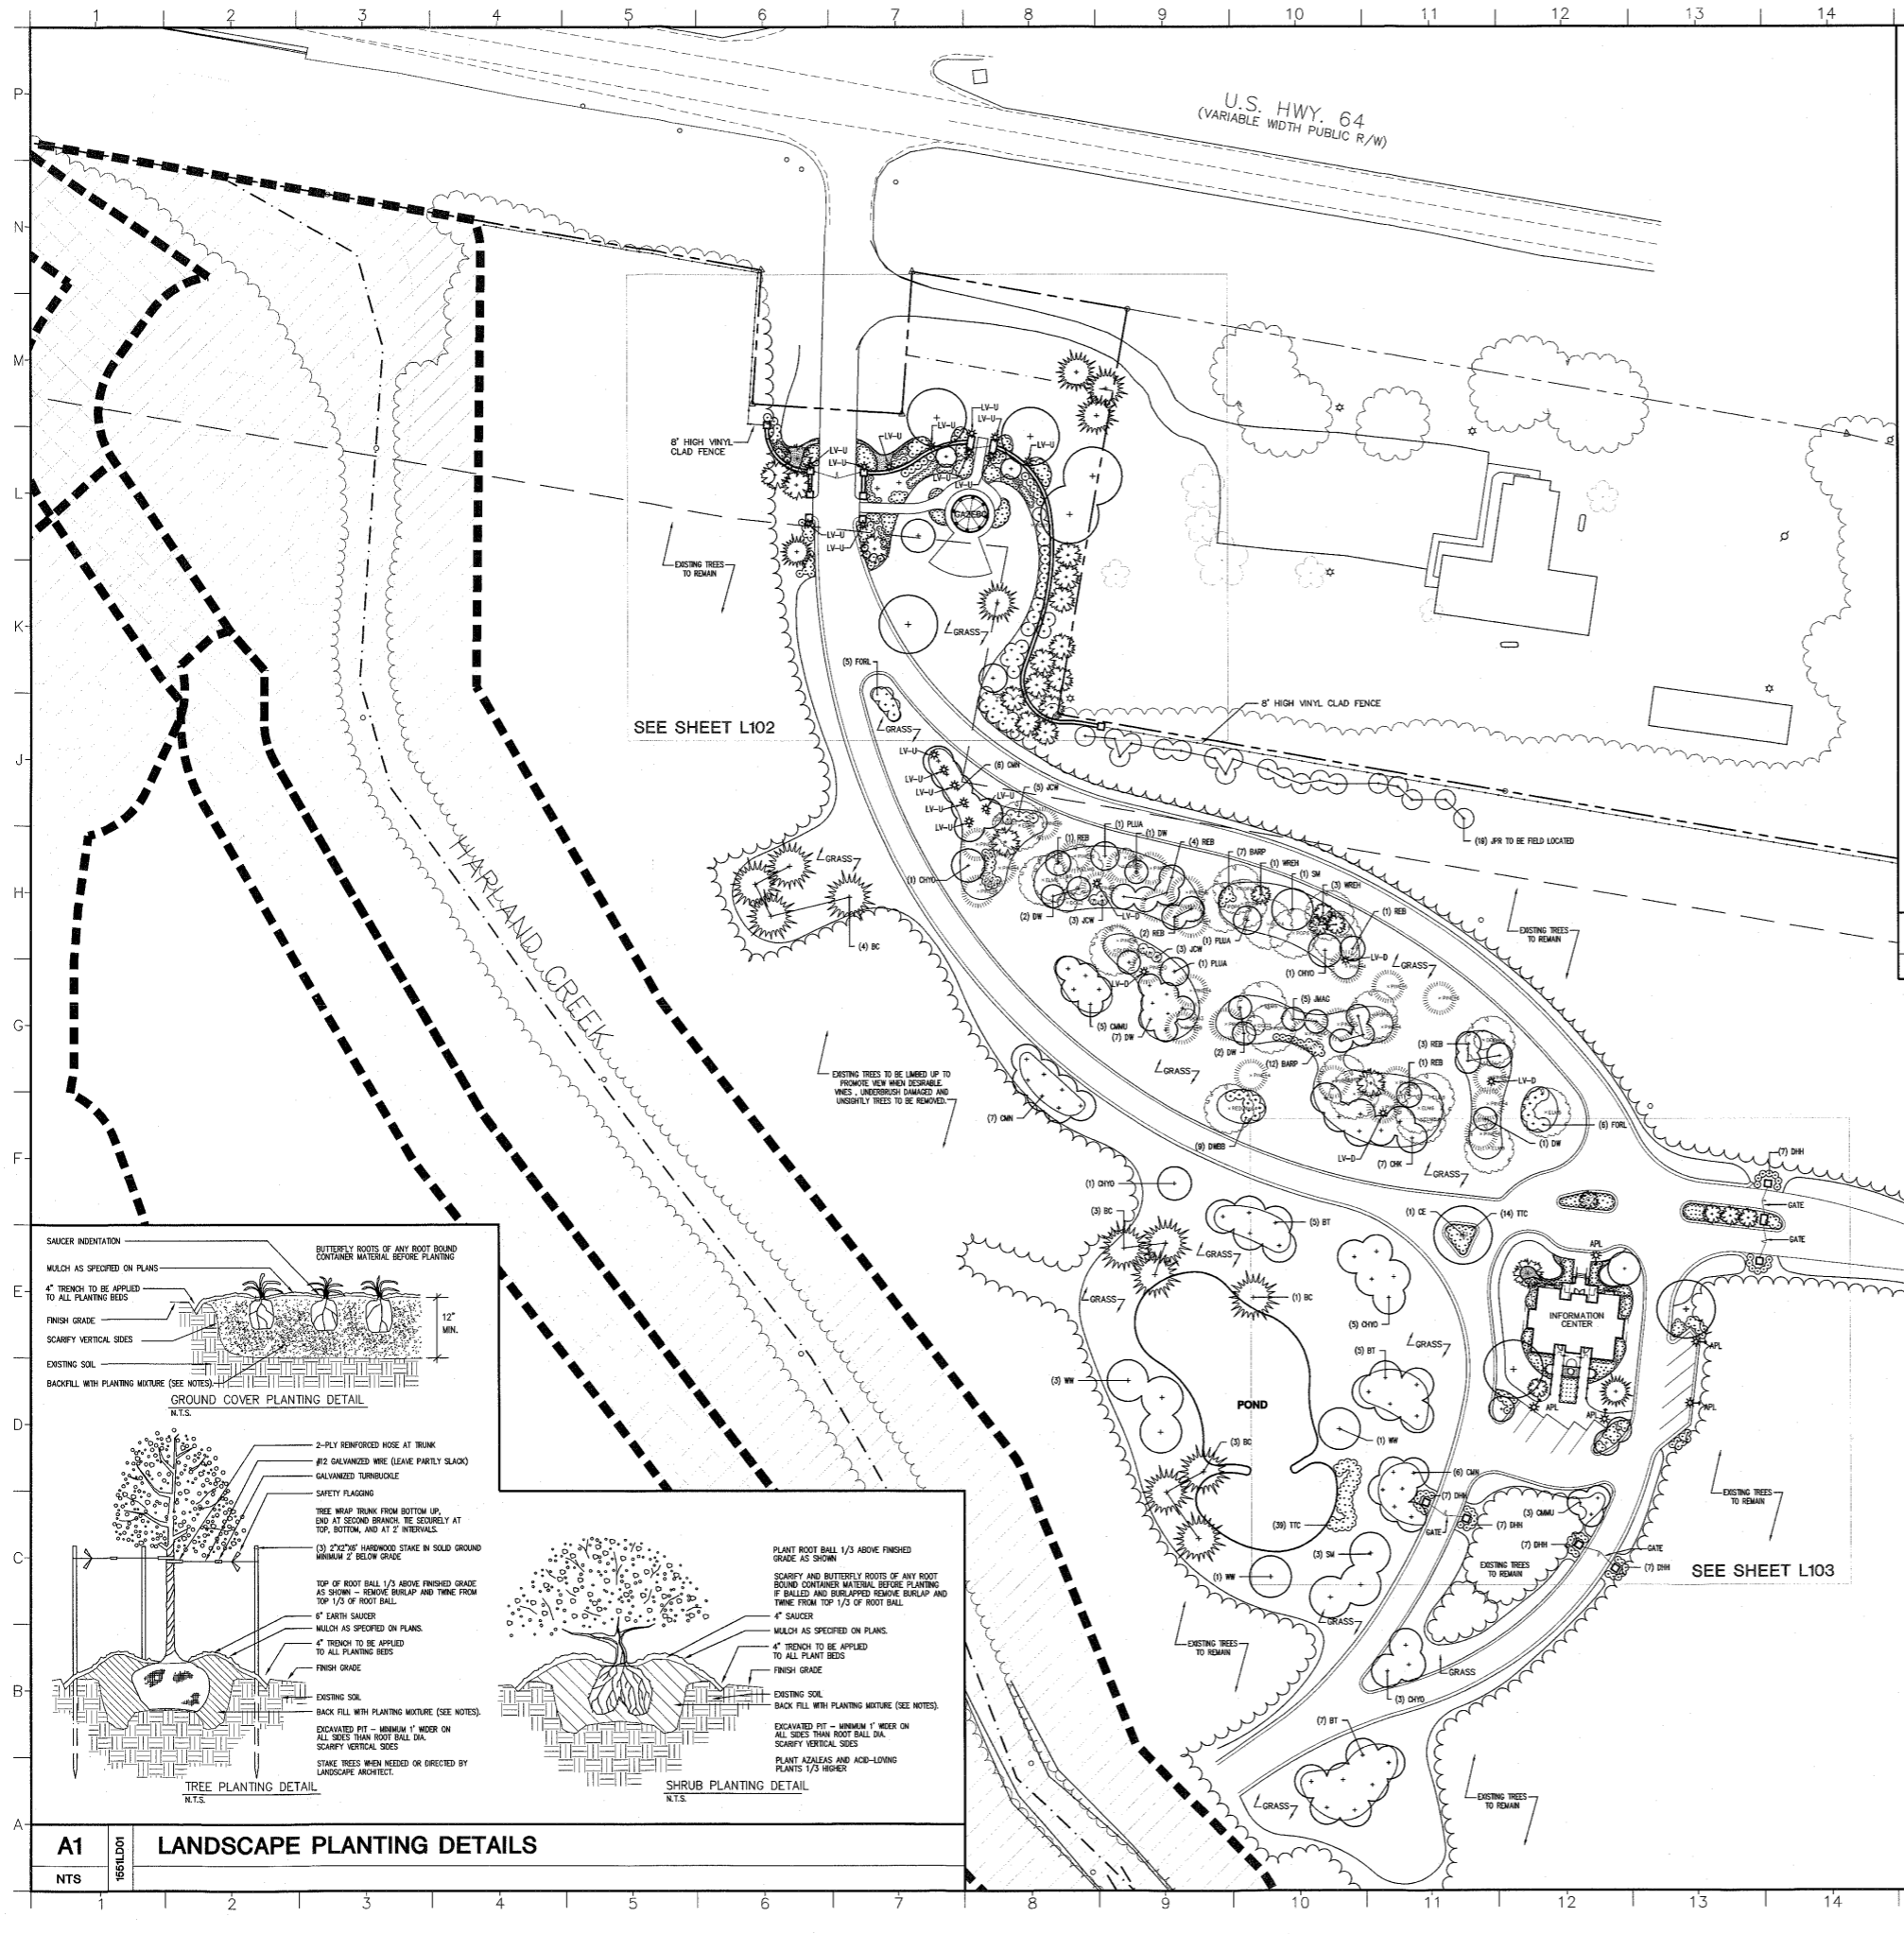

GROUND COVER				
QTY.	CODE	COMMON NAME	SCIENTIFIC NAME	SIZE HANDLING
255	MG	MONDO GRASS	OPHIOPOGON JAPONICUS	2" POTS CONT.
73	TTC	TOM THUMB COTONEASTER	COTONEASTER DAMMERI 'TOM THUMB'	3 GAL. CONT.
54	SML	SNOW MUFFIN LOROPETALUM	LOROPETALUM CHINENSIS 'SNOW MUFFIN'	3 GAL. CONT.
224	VLIR	VARIEGATED LIRIOPE	LIRIOPE MUSCARI 'VARIEGATA'	2" POTS CONT.

SHRUBS				
QTY.	CODE	COMMON NAME	SCIENTIFIC NAME	SIZE HANDLING
8	CV	CHINDO VIBURNUM	VIBURNUM AWABUKI 'CHINDO'	4' CONT.
30	CA	CONFETTI ABELIA	ABELIA GRANDIFLORA 'CONFETTI'	3 GAL. CONT.
15	DWB	DWARF BURNING BUSH	EUONYMUS ALATUS 'COMPACTUS'	3 GAL. CONT.
62	DGAR	DWARF GARDENIA	GARDENIA JASMINOIDES 'RADICANS'	3 GAL. CONT.
81	DHH	DWARF HORNED HOLLY	ILEX CORNUTA 'ROTUNDA'	3 GAL. CONT.
69	SDH	DWARF YAUPOH HOLLY	ILEX VOMITORIA 'STOKES DWARF'	3 GAL. CONT.
21	FORL	FORSYTHIA 'LYNWOOD'	FORSYTHIA X INTERMEDIA 'LYNWOOD'	3 GAL. CONT.
11	JCW	JAPANESE CAMELLIA	CAMELLIA JAPONICA 'WILSON'	3 GAL. CONT.
19	JPR	JAPANESE PRIVET	LIGUSTRUM JAPONICUM	4' CONT.
87	SPLP	LITTLE PRINCESS SPIRAEA	SPIRAEA JAPONICA 'LITTLE PRINCESS'	3 GAL. CONT.
50	BARP	PURPLE BARBERRY	BERBERIS THUNBERGI VAR. ATOURPURPUREA	3 GAL. CONT.
30	RL	RUBY LOROPETALUM	LOROPETALUM CHINENSIS VAR. RUBRA	3 GAL. CONT.
45	STH	SOFT TOUCH HOLLY	ILEX CRENATA 'SOFT TOUCH'	3 GAL. CONT.
32	SKO	SUNNY KNOCK OUT ROSE	ROSA 'RASSUNNY'	3 GAL. CONT.
5	ZFL	ZHUZHOU FUSCHIA LOROPETALUM	LOROPETALUM RUBRUM 'ZHUZHOU FUSCHIA'	3 GAL. CONT.

ORNAMENTAL TREES				
QTY.	CODE	COMMON NAME	SCIENTIFIC NAME	SIZE HANDLING
14	DW	FLOWERING DOGWOOD	CORNUS FLORIDA	1 1/2" CAL. CONT.
5	JMAG	JANE MAGNOLIA	MAGNOLIA X JANE	1 1/2" CAL. CONT.
7	CHK	KWANZAN CHERRY	PRUNUS SERRULATA 'KWANZAN'	1 1/2" CAL. CONT.
11	CMUJ	MUSKOGEE CREPE MYRTLE	LAGERSTROEMIA INDICA 'MUSKOGEE'	7' CONT.
21	CNN	NATCHEZ CREPE MYRTLE	LAGERSTROEMIA INDICA 'NATCHEZ'	7' CONT.
4	PLUA	PURPLE LEAF PLUM	PRUNUS CERASIFERA 'AUTORPURPUREA'	6' CONT.
12	REB	REDBUD 'FOREST PANSY'	CERCIS CANADENSIS 'FOREST PANSY'	6' CONT.
5	WRH	WINTER RED HOLLY	ILEX VERTICILLATA 'WINTER RED'	6' CONT.
13	CHYO	YOSHINO CHERRY	PRUNUS YEDDENSIS	6' CONT.

EVERGREEN TREES				
QTY.	CODE	COMMON NAME	SCIENTIFIC NAME	SIZE HANDLING
11	AH	AMERICAN HOLLY	ILEX OPACA	6' B & B
4	BH(T)	BURFORD HOLLY (TREE FORM)	ILEX CORNUTA 'BURFORDII' (TREE FORM)	7' B & B
2	CHEM	CANADIAN HEMLOCK	TSUGA CANADENSIS	7' B & B
4	DC	DEODAR CEDAR	CEDRUS DEODARA	7' B & B
7	EBH	EMILY BRUNNER HOLLY	ILEX X EMILY BRUNNER	7' B & B
2	LO	LAUREL OAK	QUERCUS LAURIFOLIA	7' B & B
2	LGM	LITTLE GEM MAGNOLIA	MAGNOLIA GRANDIFLORA 'LITTLE GEM'	6' B & B
4	SM	SOUTHERN MAGNOLIA	MAGNOLIA GRANDIFLORA	7' B & B

DECIDUOUS TREES				
QTY.	CODE	COMMON NAME	SCIENTIFIC NAME	SIZE HANDLING
11	BC	BALD CYPRESS	TAXODIUM DISTICHUM	6' CONT.
17	BT	BLACK TUPELO	NYSSA SYLVATICA	2" CAL. B & B
2	CE	CHINESE ELM	ULMUS PARVIFOLIA	2" CAL. B & B
4	FMOG	OCTOBER GLORY RED MAPLE	ACER RUBRUM 'OCTOBER GLORY'	2" CAL. B & B
5	WW	WEeping WILLOW	SALIX BABYLONICA	8' B & B

G15 **LANDSCAPE PLANT LIST**

CPA PLANNING
ARCHITECTURE
 INTERIOR DESIGN
 LANDSCAPE ARCHITECTURE
 6330 QUADRANGLE DR., SUITE 260 CHAPEL HILL, NC 27517
 PHONE: 919-489-1771 FAX: 919-489-3466

EXTERIOR LIGHT LEGEND
 LV-D ✨ LOW VOLTAGE DOWN LIGHT
 LV-U ✨ LOW VOLTAGE UP LIGHT
 APL ✨ AREA POST LIGHT 14" HIGH
 100 WATT, HPS

BELMEADE FARM CEMETERY
 CENTER TOWNSHIP
 CHATHAM COUNTY
 NORTH CAROLINA


REVISIONS

The use of these plans and specifications shall be restricted to the original site for which they were prepared and publication thereof is expressly limited to such use. For any reproduction or distribution by any method, in whole or in part, is prohibited. The title to the plans and specifications remains in the architect's office. Visual contact with these plans and specifications shall constitute prima facie evidence of the acceptance of these restrictions.

NORTH CAROLINA
 LANDSCAPE ARCHITECT
 JAMES & DAVIS
 374
CHATHAM COUNTY
 LANDSCAPE ARCHITECT
 JAMES & DAVIS
 0044

LANDSCAPE PLAN PLANT LIST AND DETAILS

DATE	9/29/08	DRAWING NO.	L101
DESIGN	JD	PROJECT NO.	1551
DRAWN	DC	FILE #	1551L101
SCALE	AS NOTED	of	

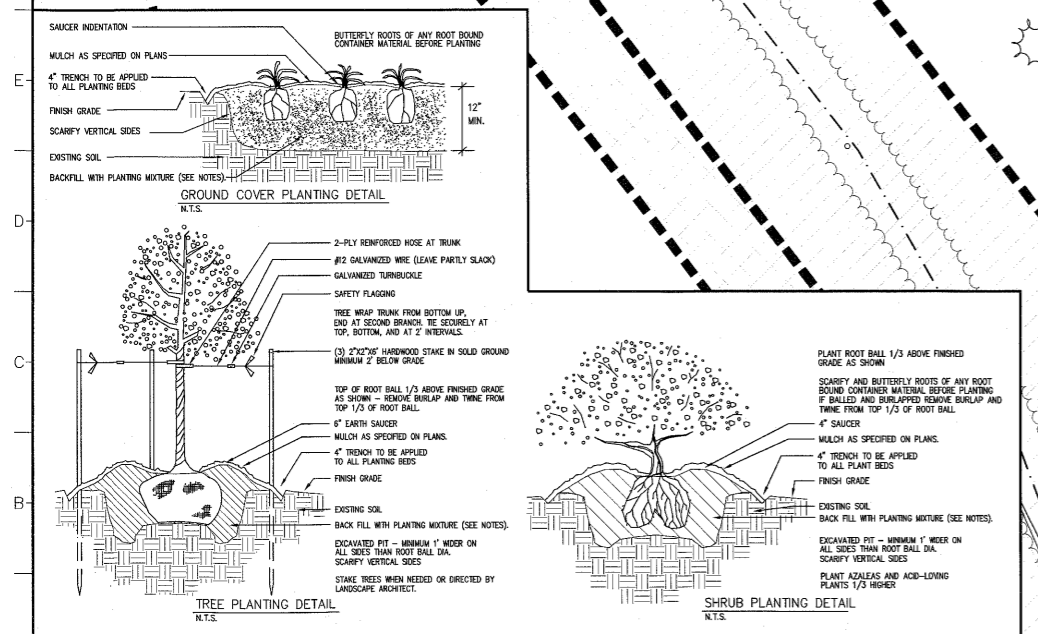

A1 **LANDSCAPE PLANTING DETAILS**

A16 **LANDSCAPE PLAN**

J:\1551\1551\1551L101.dwg, 9/29/2008 4:53:05 PM, 1:1

QTY.	CODE	COMMON NAME	SCIENTIFIC NAME	SIZE	HANDLING
255	MG	MONDO GRASS	OPHIOPOGON JAPONICUS	2" POTS	CONT.
73	TTC	TOM THUMB COTONEASTER	COTONEASTER DAMMERI 'TOM THUMB'	3 GAL.	CONT.
54	SML	SNOW MUFFIN LOROPETALUM	LOROPETALUM CHINENSIS 'SNOW MUFFIN'	3 GAL.	CONT.
224	VLR	VARIEGATED LIRIOPE	LIRIOPE MUSCARI 'VAREGATA'	2" POTS	CONT.

QTY.	CODE	COMMON NAME	SCIENTIFIC NAME	SIZE	HANDLING
8	CV	CHINDO VIBURNUM	VIBURNUM AWABUKI 'CHINDO'	4'	CONT.
30	CA	CONFETTI ABELIA	ABELIA GRANDIFLORA 'CONFETTI'	3 GAL.	CONT.
15	DHBF	DWARF BURNING BUSH	EUONYMUS ALATUS 'COMPACTUS'	3 GAL.	CONT.
62	DGAR	DWARF GARDENIA	GARDENIA JASMINOIDES 'RADICANS'	3 GAL.	CONT.
81	DHH	DWARF HORNED HOLLY	ILEX CORNUTA 'ROTUNDA'	3 GAL.	CONT.
69	SDYH	DWARF YAU-PON HOLLY	ILEX VOMITORIA 'STOKES DWARF'	3 GAL.	CONT.
21	FORL	FORSYTHIA 'LYNWOOD'	FORSYTHIA X INTERMEDIA 'LYNWOOD'	3 GAL.	CONT.
11	JCW	JAPANESE CAMELLIA	CAMELLIA JAPONICA 'WILSON'	3 GAL.	CONT.
19	JPR	JAPANESE PRIVET	LIGUSTRUM JAPONICUM	4'	CONT.
87	SPLP	LITTLE PRINCESS SPIRAEA	SPIRAEA JAPONICA 'LITTLE PRINCESS'	3 GAL.	CONT.
50	BARP	PURPLE BARBERRY	BERBERIS THUNBERGI VAR. ATOPURPUREA	3 GAL.	CONT.
30	RL	RUBY LOROPETALUM	LOROPETALUM CHINENSIS VAR. RUBRA	3 GAL.	CONT.
45	STH	SOFT TOUCH HOLLY	ILEX CRENATA 'SOFT TOUCH'	3 GAL.	CONT.
32	SKO	SUNNY KNOCK OUT ROSE	ROSA 'RADSLUNNY'	3 GAL.	CONT.
5	ZFL	ZHUZHOU FUSCHIA LOROPETALUM	LOROPETALUM RUBRUM 'ZHUZHOU FUSCHIA'	3 GAL.	CONT.

QTY.	CODE	COMMON NAME	SCIENTIFIC NAME	SIZE	HANDLING
14	DW	FLOWERING DOGWOOD	CORNUS FLORIDA	1 1/2" CAL.	CONT.
5	JMAG	JANE MAGNOLIA	MAGNOLIA X JANE	1 1/2" CAL.	CONT.
7	CHK	KWANZAN CHERRY	PRUNUS SERRULATA 'KWANZAN'	1 1/2" CAL.	CONT.
11	CMU	MUSKOGEE CREPE MYRTLE	LAGERSTROEMIA INDICA 'MUSKOGEE'	7"	CONT.
21	CMN	NATCHEZ CREPE MYRTLE	LAGERSTROEMIA INDICA 'NATCHEZ'	7"	CONT.
4	PLJA	PURPLE LEAF PLUM	PRUNUS CERASIFERA 'AUTORPURPUREA'	6"	CONT.
12	REB	REDBUD FOREST PANSY	CERCIS CANADENSIS 'FOREST PANSY'	6"	CONT.
13	WREH	WINTER RED HOLLY	ILEX VERTICILLATA 'WINTER RED'	6"	CONT.
5	CHYO	YOSHINO CHERRY	PRUNUS YEDOENSIS	6"	CONT.

QTY.	CODE	COMMON NAME	SCIENTIFIC NAME	SIZE	HANDLING
11	AH	AMERICAN HOLLY	ILEX OPACA	6"	B & B
4	BH(T)	BURFORD HOLLY (TREE FORM)	ILEX CORNUTA 'BURFORDI' (TREE FORM)	7"	B & B
2	CHEM	CANADIAN HEMLOCK	TSUGA CANADENSIS	7"	B & B
4	DC	DECODAR CEDAR	CEDRUS DEODARA	7"	B & B
7	EBH	EMILY BRUNNER HOLLY	ILEX X EMILY BRUNNER	7"	B & B
2	LO	LAUREL OAK	QUERCUS LAURIFOLIA	7"	B & B
2	LGM	LITTLE GEM MAGNOLIA	MAGNOLIA GRANDIFLORA 'LITTLE GEM'	6"	B & B
4	SM	SOUTHERN MAGNOLIA	MAGNOLIA GRANDIFLORA	7"	B & B

QTY.	CODE	COMMON NAME	SCIENTIFIC NAME	SIZE	HANDLING
11	BC	BALD CYPRESS	TAXODIUM DISTICHUM	6"	CONT.
17	BT	BLACK TUPELO	NYSSA SYLVATICA	2" CAL.	B & B
2	CE	CHINESE ELM	ULMUS PARVIFOLIA	2" CAL.	B & B
4	RMOG	OCTOBER GLORY RED MAPLE	ACER RUBRUM 'OCTOBER GLORY'	2" CAL.	B & B
5	YW	WEeping WILLOW	SALIX BABYLONICA	6"	B & B

G1 LANDSCAPE PLANT LIST



CPA PLANNING
ARCHITECTURE
INTERIOR DESIGN
LANDSCAPE ARCHITECTURE
6330 QUADRANGLE DR., SUITE 260 CHAPEL HILL, NC 27517
PHONE: 919-489-1771 FAX: 919-489-3466

EXTERIOR LIGHT LEGEND
LV-D ✨ LOW VOLTAGE DOWN LIGHT
LV-U ✨ LOW VOLTAGE UP LIGHT
APL ✨ AREA POST LIGHT 14" HIGH
100 WATT, HPS

BELMEADE FARM CEMETERY
CENTER TOWNSHIP
CHATHAM COUNTY
NORTH CAROLINA

REVISIONS



The use of these plans and specifications shall be restricted to the original site for which they were prepared and publication thereof is expressly limited to such use. Any reproduction or publication by any method in whole or in part is prohibited. This is to the plans and specifications remain in the architect's physical possession. Visual contact with these plans and specifications shall constitute notice of the restriction of their use.

NORTH CAROLINA
LANDSCAPE ARCHITECTURE
374
JAMES G. DAVIS

COMMUNITY PLANNING & ARCHITECTURAL SERVICES
CERT. NO. 8714
JAMES G. DAVIS

ENTRANCE GATE LANDSCAPE PLAN

DATE	9/28/08	DRAWING NO.	L102
DESIGN	JD		
DRAWN	DC		
PROJECT NO.	1551		
FILE #	1551L102		
SCALE	AS NOTED		

 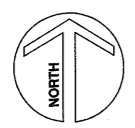

A1 1551CP01 ENTRANCE LANDSCAPE PLAN
1" = 10'

J:\1551\Belmeade\1551L102.dwg, 9/29/2008 4:28:12 PM, 1:1

GROUND COVER				
QTY.	CODE	COMMON NAME	SCIENTIFIC NAME	HANDLING
255	MG	MONDO GRASS	OPHIOPOGON JAPONICUS	2" POTS CONT.
73	TTC	TOM THUMB COTONEASTER	COTONEASTER 'TOM THUMB'	3 GAL. CONT.
54	SML	SNOW MUFFIN LOROPETALUM	LOROPETALUM CHINENSIS 'SNOW MUFFIN'	3 GAL. CONT.
224	YLR	VARIEGATED LIRIOPE	LIRIOPE MUSCARI 'VAREGATA'	2" POTS CONT.


SHRUBS				
QTY.	CODE	COMMON NAME	SCIENTIFIC NAME	HANDLING
8	CV	OHIO VIBURNUM	VIBURNUM AWABUKI 'OHIO'	4" CONT.
30	CA	CONFETTI ABELIA	ABELIA GRANDIFLORA 'CONFETTI'	3 GAL. CONT.
15	DWB	DWARF BURNING BUSH	EUONYMUS ALATUS 'COMPACTUS'	3 GAL. CONT.
62	DGAR	DWARF GARDENIA	GARDENIA JASMINOIDES 'RADICANS'	3 GAL. CONT.
81	DWH	DWARF HORNED HOLLY	ILEX CORNUTA 'ROTUNDA'	3 GAL. CONT.
69	SDH	DWARF YAUPOIN HOLLY	ILEX VOMITORIA 'STOKES DWARF'	3 GAL. CONT.
21	FORL	FORSYTHIA 'LYNWOOD'	FORSYTHIA X INTERMEDIA 'LYNWOOD'	3 GAL. CONT.
11	JCW	JAPANESE CAMELLIA	CAMELLIA JAPONICA 'WILSON'	3 GAL. CONT.
19	JPR	JAPANESE PRIVET	LIGUSTRUM JAPONICUM	4" CONT.
87	SPLP	LITTLE PRINCESS SPIRAEA	SPIRAEA JAPONICA 'LITTLE PRINCESS'	3 GAL. CONT.
50	BARP	PURPLE BARBERRY	BERBERIS THUNBERGI VAR. ATOPURPUREA	3 GAL. CONT.
30	RL	RUBY LOROPETALUM	LOROPETALUM CHINENSIS VAR. RUBRA	3 GAL. CONT.
45	STH	SOFT TOUCH HOLLY	ILEX ORENATA 'SOFT TOUCH'	3 GAL. CONT.
32	SKO	SUNNY KNOCK OUT ROSE	ROSA 'RADSUNNY'	3 GAL. CONT.
5	ZFL	ZHUZHOU FUSCHIA LOROPETALUM	LOROPETALUM RUBRUM 'ZHUZHOU FUSCHIA'	3 GAL. CONT.

ORNAMENTAL TREES				
QTY.	CODE	COMMON NAME	SCIENTIFIC NAME	HANDLING
14	DW	FLOWERING DOGWOOD	CORNUS FLORIDA	1 1/2" CAL. CONT.
5	JMAG	JANE MAGNOLIA	MAGNOLIA X JANE	1 1/2" CAL. CONT.
7	CHK	KWANZAN CHERRY	PRUNUS SERRULATA 'KWANZAN'	1 1/2" CAL. CONT.
11	DMU	MUSKOGEE CREPE MYRTLE	LAGERSTROEMIA INDICA 'MUSKOGEE'	7" CONT.
21	DAN	NATCHEZ CREPE MYRTLE	LAGERSTROEMIA INDICA 'NATCHEZ'	7" CONT.
4	PLUA	PURPLE LEAF PLUM	PRUNUS CERASIFERA 'AUTORPURPUREA'	6" CONT.
12	REB	REDBUD 'FOREST PANSY'	CERCIS CANADENSIS 'FOREST PANSY'	6" CONT.
5	WRH	WINTER RED HOLLY	ILEX VERTICILLATA 'WINTER RED'	6" CONT.
13	OHYO	YOSHINO CHERRY	PRUNUS YEDOENSIS	6" CONT.

EVERGREEN TREES				
QTY.	CODE	COMMON NAME	SCIENTIFIC NAME	HANDLING
11	AH	AMERICAN HOLLY	ILEX OPACA	6" B & B
4	BH(T)	BURFORD HOLLY (TREE FORM)	ILEX CORNUTA 'BURFORDII' (TREE FORM)	7" B & B
2	CHEM	CANADIAN HEMLOCK	TSUGA CANADENSIS	7" B & B
4	DC	DEODAR CEDAR	CEDRUS DEODARA	7" B & B
7	EBH	EMILY BRUNNER HOLLY	ILEX X EMILY BRUNNER	7" B & B
2	LO	LAUREL OAK	QUERCUS LAURIFOLIA	7" B & B
2	LGM	LITTLE GEM MAGNOLIA	MAGNOLIA GRANDIFLORA 'LITTLE GEM'	6" B & B
4	SM	SOUTHERN MAGNOLIA	MAGNOLIA GRANDIFLORA	7" B & B

DECIDUOUS TREES				
QTY.	CODE	COMMON NAME	SCIENTIFIC NAME	HANDLING
11	BC	BALD CYPRESS	TAXODIUM DISTICHUM	6" CONT.
17	BT	BLACK TUPELO	NYSSA SYLVATICA	2" CAL. B & B
2	CE	CHINESE ELM	ULMUS PARVIFOLIA	2" CAL. B & B
4	RMOG	OCTOBER GLORY RED MAPLE	ACER RUBRUM 'OCTOBER GLORY'	2" CAL. B & B
5	WW	WEEPING WILLOW	SALIX BABYLONICA	6" B & B

G1 LANDSCAPE PLANT LIST

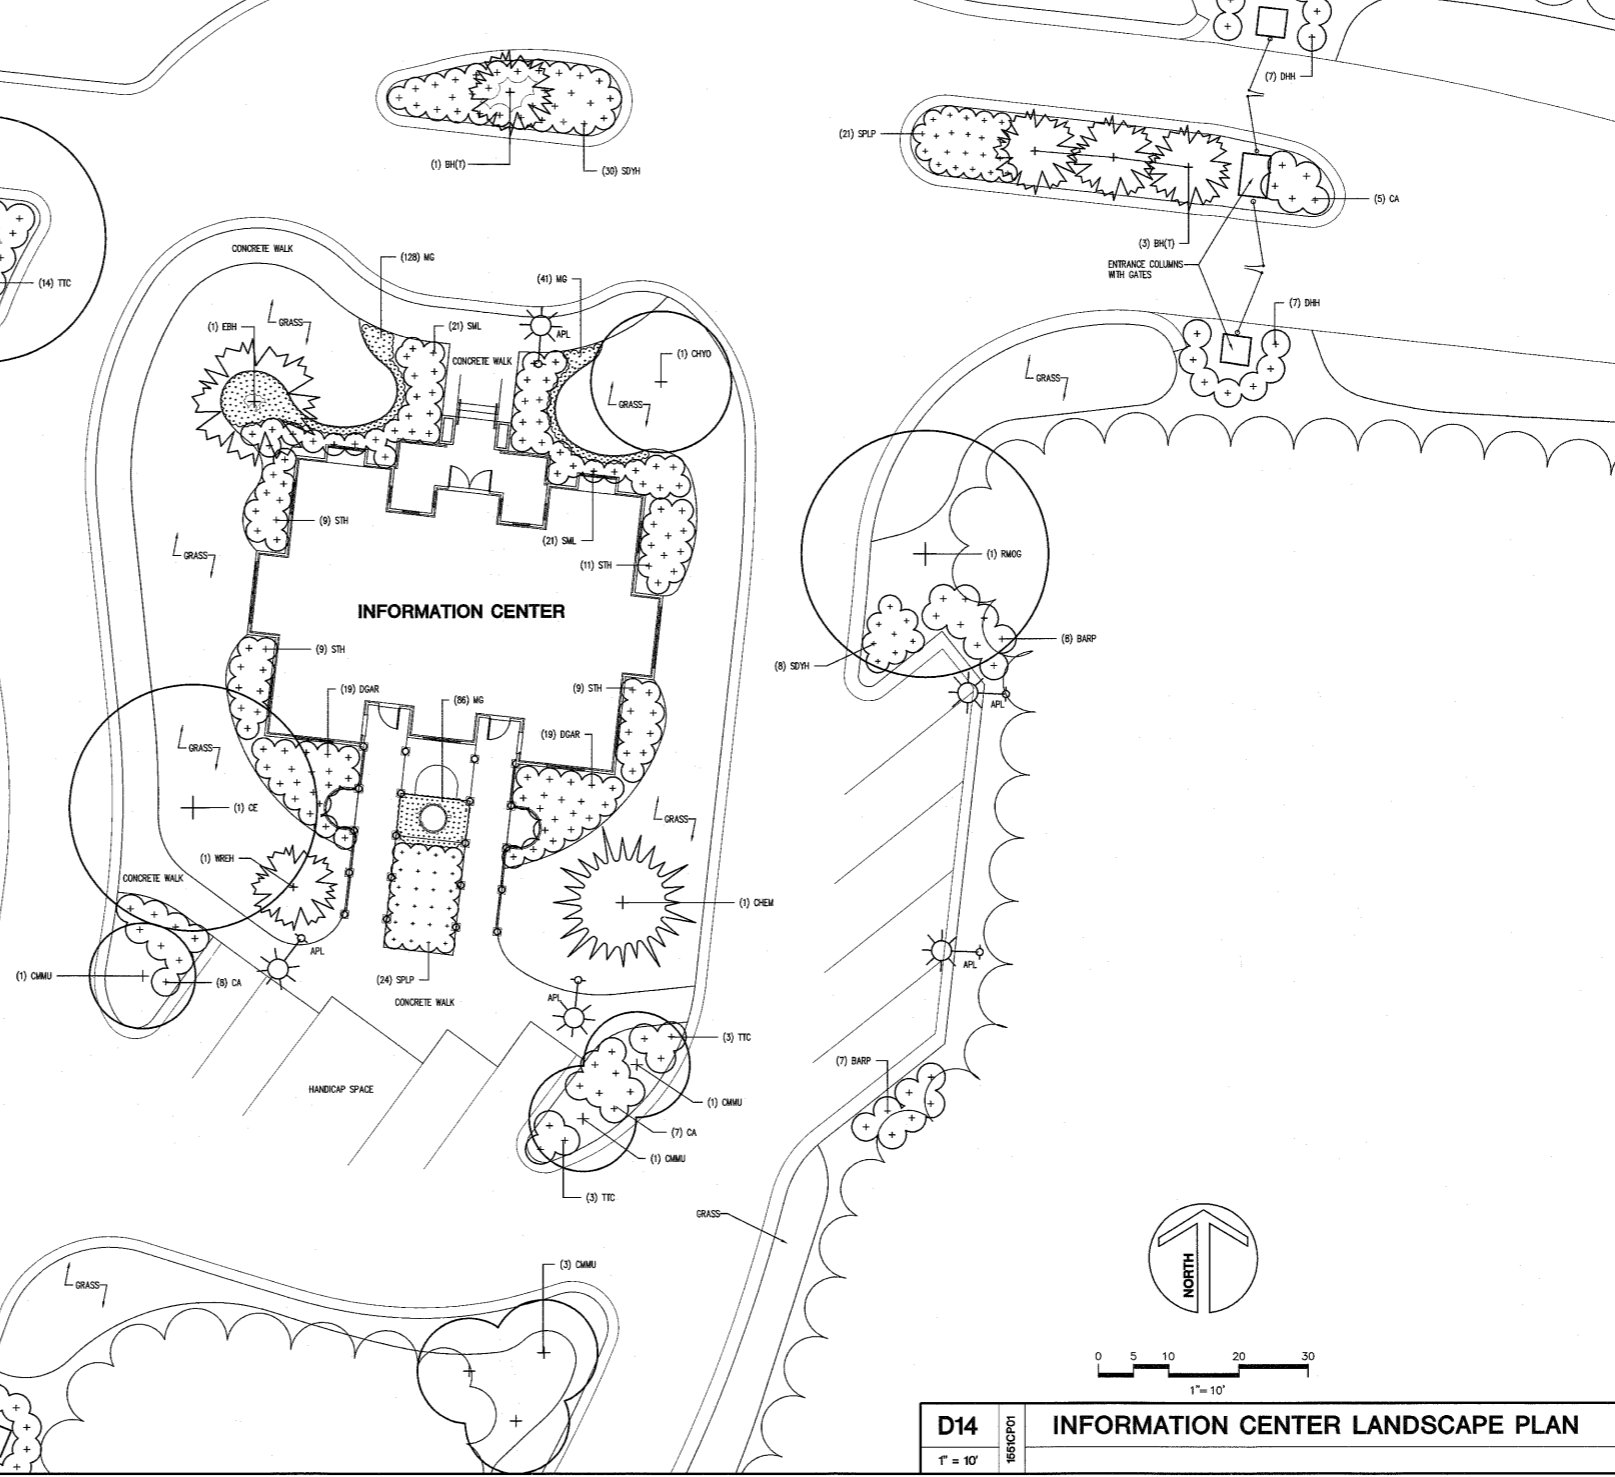

D14 INFORMATION CENTER LANDSCAPE PLAN
1" = 10'

CPA PLANNING
ARCHITECTURE
INTERIOR DESIGN
LANDSCAPE ARCHITECTURE
6330 QUADRANGLE DR., SUITE 260 CHAPEL HILL, NC 27517
PHONE: 919-489-1771 FAX: 919-489-3466

EXTERIOR LIGHT LEGEND
LV-D ✖ LOW VOLTAGE DOWN LIGHT
LV-U ✖ LOW VOLTAGE UP LIGHT
APL ✖ AREA POST LIGHT 14' HIGH
100 WATT, HPS

BELMEADE FARM CEMETERY
CENTER TOWNSHIP
CHATHAM COUNTY
NORTH CAROLINA

REVISIONS


The use of these plans and specifications shall be restricted to the original site for which they were prepared and publication thereof in general is prohibited. No use, reproduction or publication by any method, in whole or in part, is permitted. This is the plan and specifications made in the architect's office. All other copies of these plans and specifications shall constitute prima facie evidence of the occupant of these instructions.

NORTH CAROLINA
LICENSED LANDSCAPE ARCHITECT
374
JAMES G. DAVIS

NORTH CAROLINA
LICENSED ARCHITECTURAL DRAFTER
3074
JAMES G. DAVIS


INFORMATION CENTER LANDSCAPE PLAN & ENTRANCE ELEVATION

DATE	9/29/08	DRAWING NO.	L103 of
DESIGN	JD		
DRAWN	DC		
PROJECT NO.	1551		
FILE #	1551L103		
SCALE	AS NOTED		

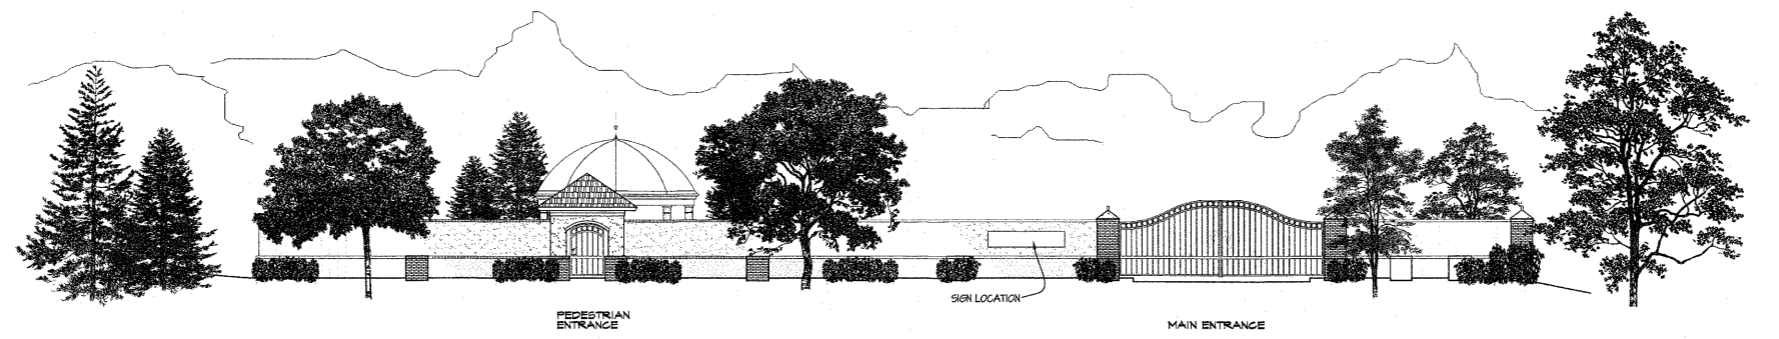


A1 ELEVATION AT PEDESTRIAN ENTRANCE AND MAIN ENTRANCE

J:\1551\1551L103.dwg, 9/29/2008 4:55:40 PM, 1:1

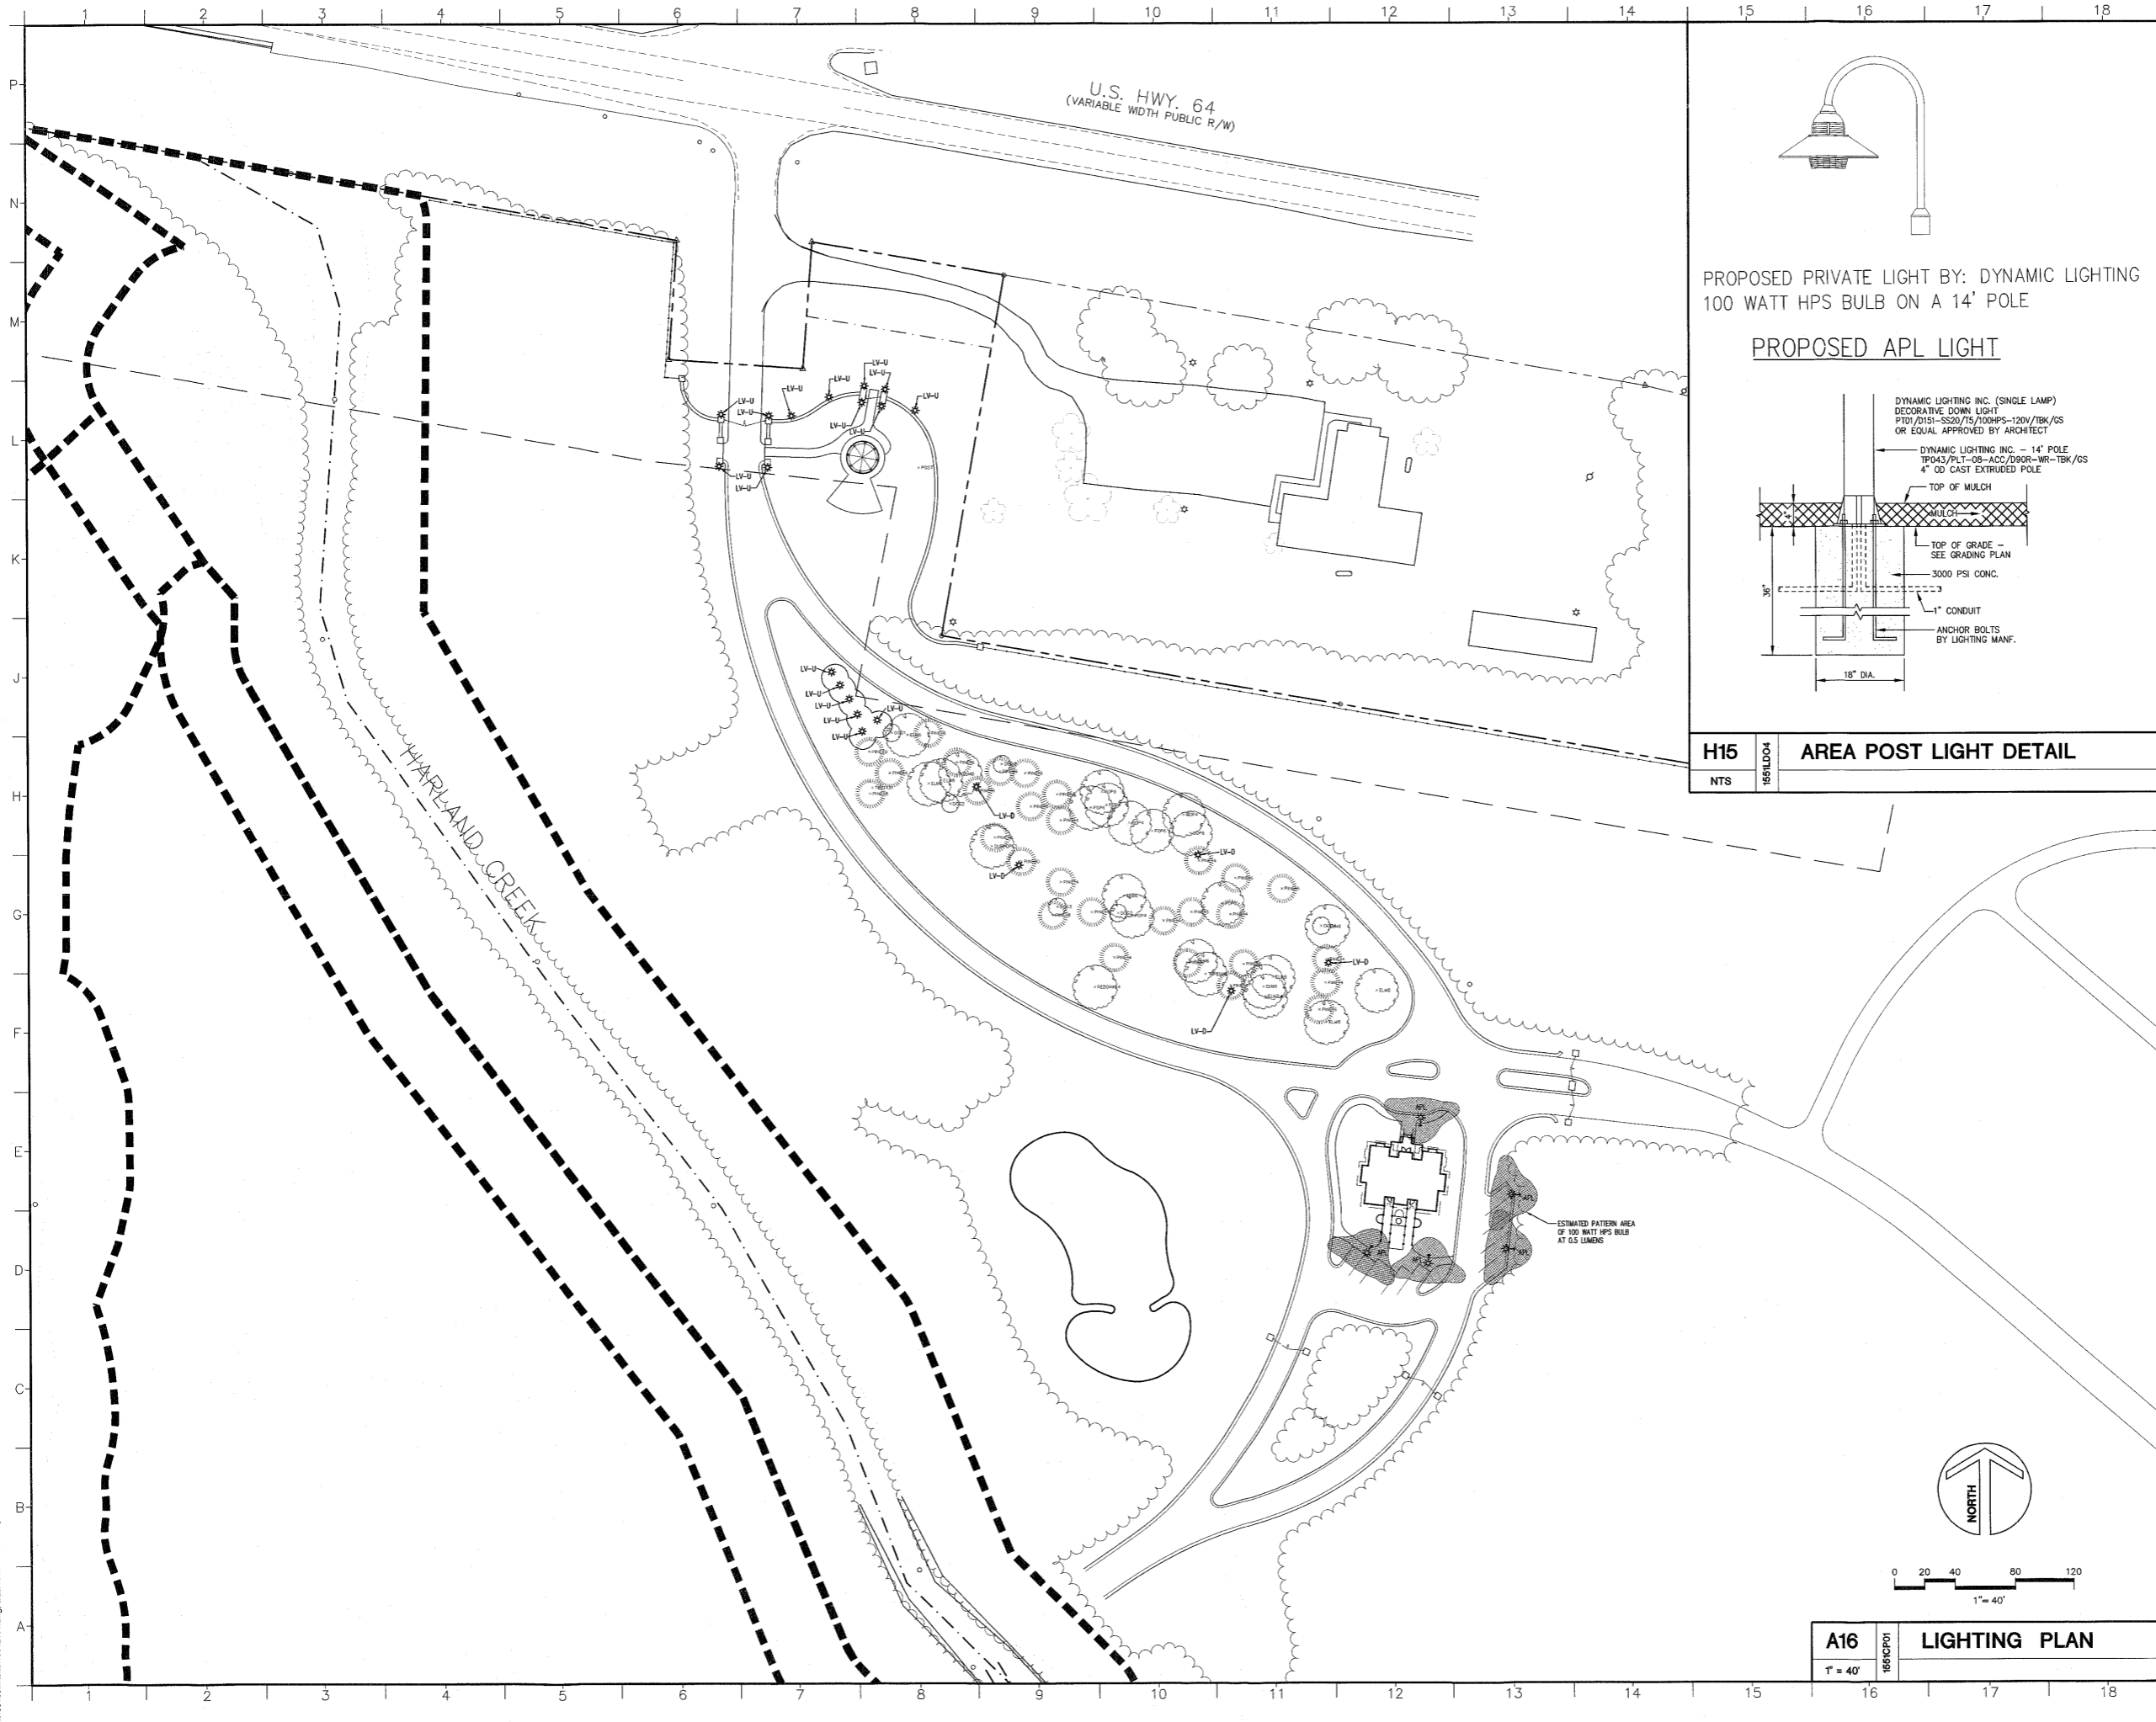


CPAA PLANNING
 ARCHITECTURE
 INTERIOR DESIGN
 LANDSCAPE ARCHITECTURE
 6330 QUADRANGLE DR., SUITE 260 CHAPEL HILL, NC 27517
 PHONE: 919-489-1771 FAX: 919-489-3466

EXTERIOR LIGHT LEGEND
 LV-D ✱ LOW VOLTAGE DOWN LIGHT
 LV-U ✱ LOW VOLTAGE UP LIGHT
 APL ✱ → AREA POST LIGHT 14' HIGH
 100 WATT, HPS

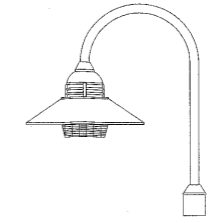

PROPOSED PRIVATE LIGHT BY: DYNAMIC LIGHTING
 100 WATT HPS BULB ON A 14' POLE

PROPOSED APL LIGHT

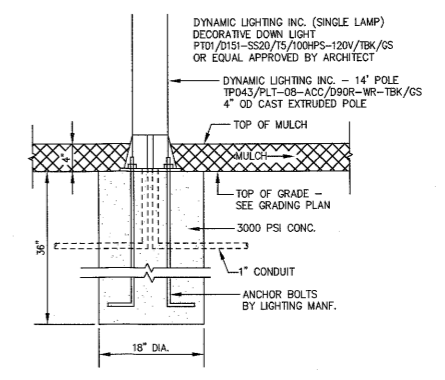

H15 1651LD04 AREA POST LIGHT DETAIL
 NTS


BELMEADE FARM CEMETERY
 CENTER TOWNSHIP
 CHATHAM COUNTY
 NORTH CAROLINA

REVISIONS

The use of these plans and specifications shall be restricted to the original site for which they were prepared and publication thereof is expressly limited to such use. No reproduction or publication by any method, in whole or in part, is prohibited. The use of these plans and specifications shall constitute prima facie evidence of the acceptance of these restrictions.




LANDSCAPE PLAN AND DETAILS

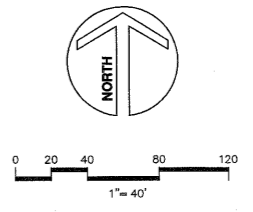


A16	1651CP01	LIGHTING PLAN	DATE: 9/29/08	DRAWING NO.:
1" = 40'			DESIGN: JD	L104
			DRAWN: DC	
			PROJECT NO. 1651	
			FILE #: 1651L104	
			SCALE: AS NOTED	of



J:\1651\1651L104.dwg 9/29/2008 4:40:37 PM, 1:1

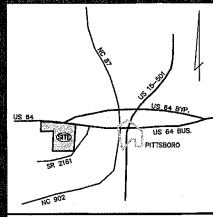

VICINITY MAP
NOT TO SCALE

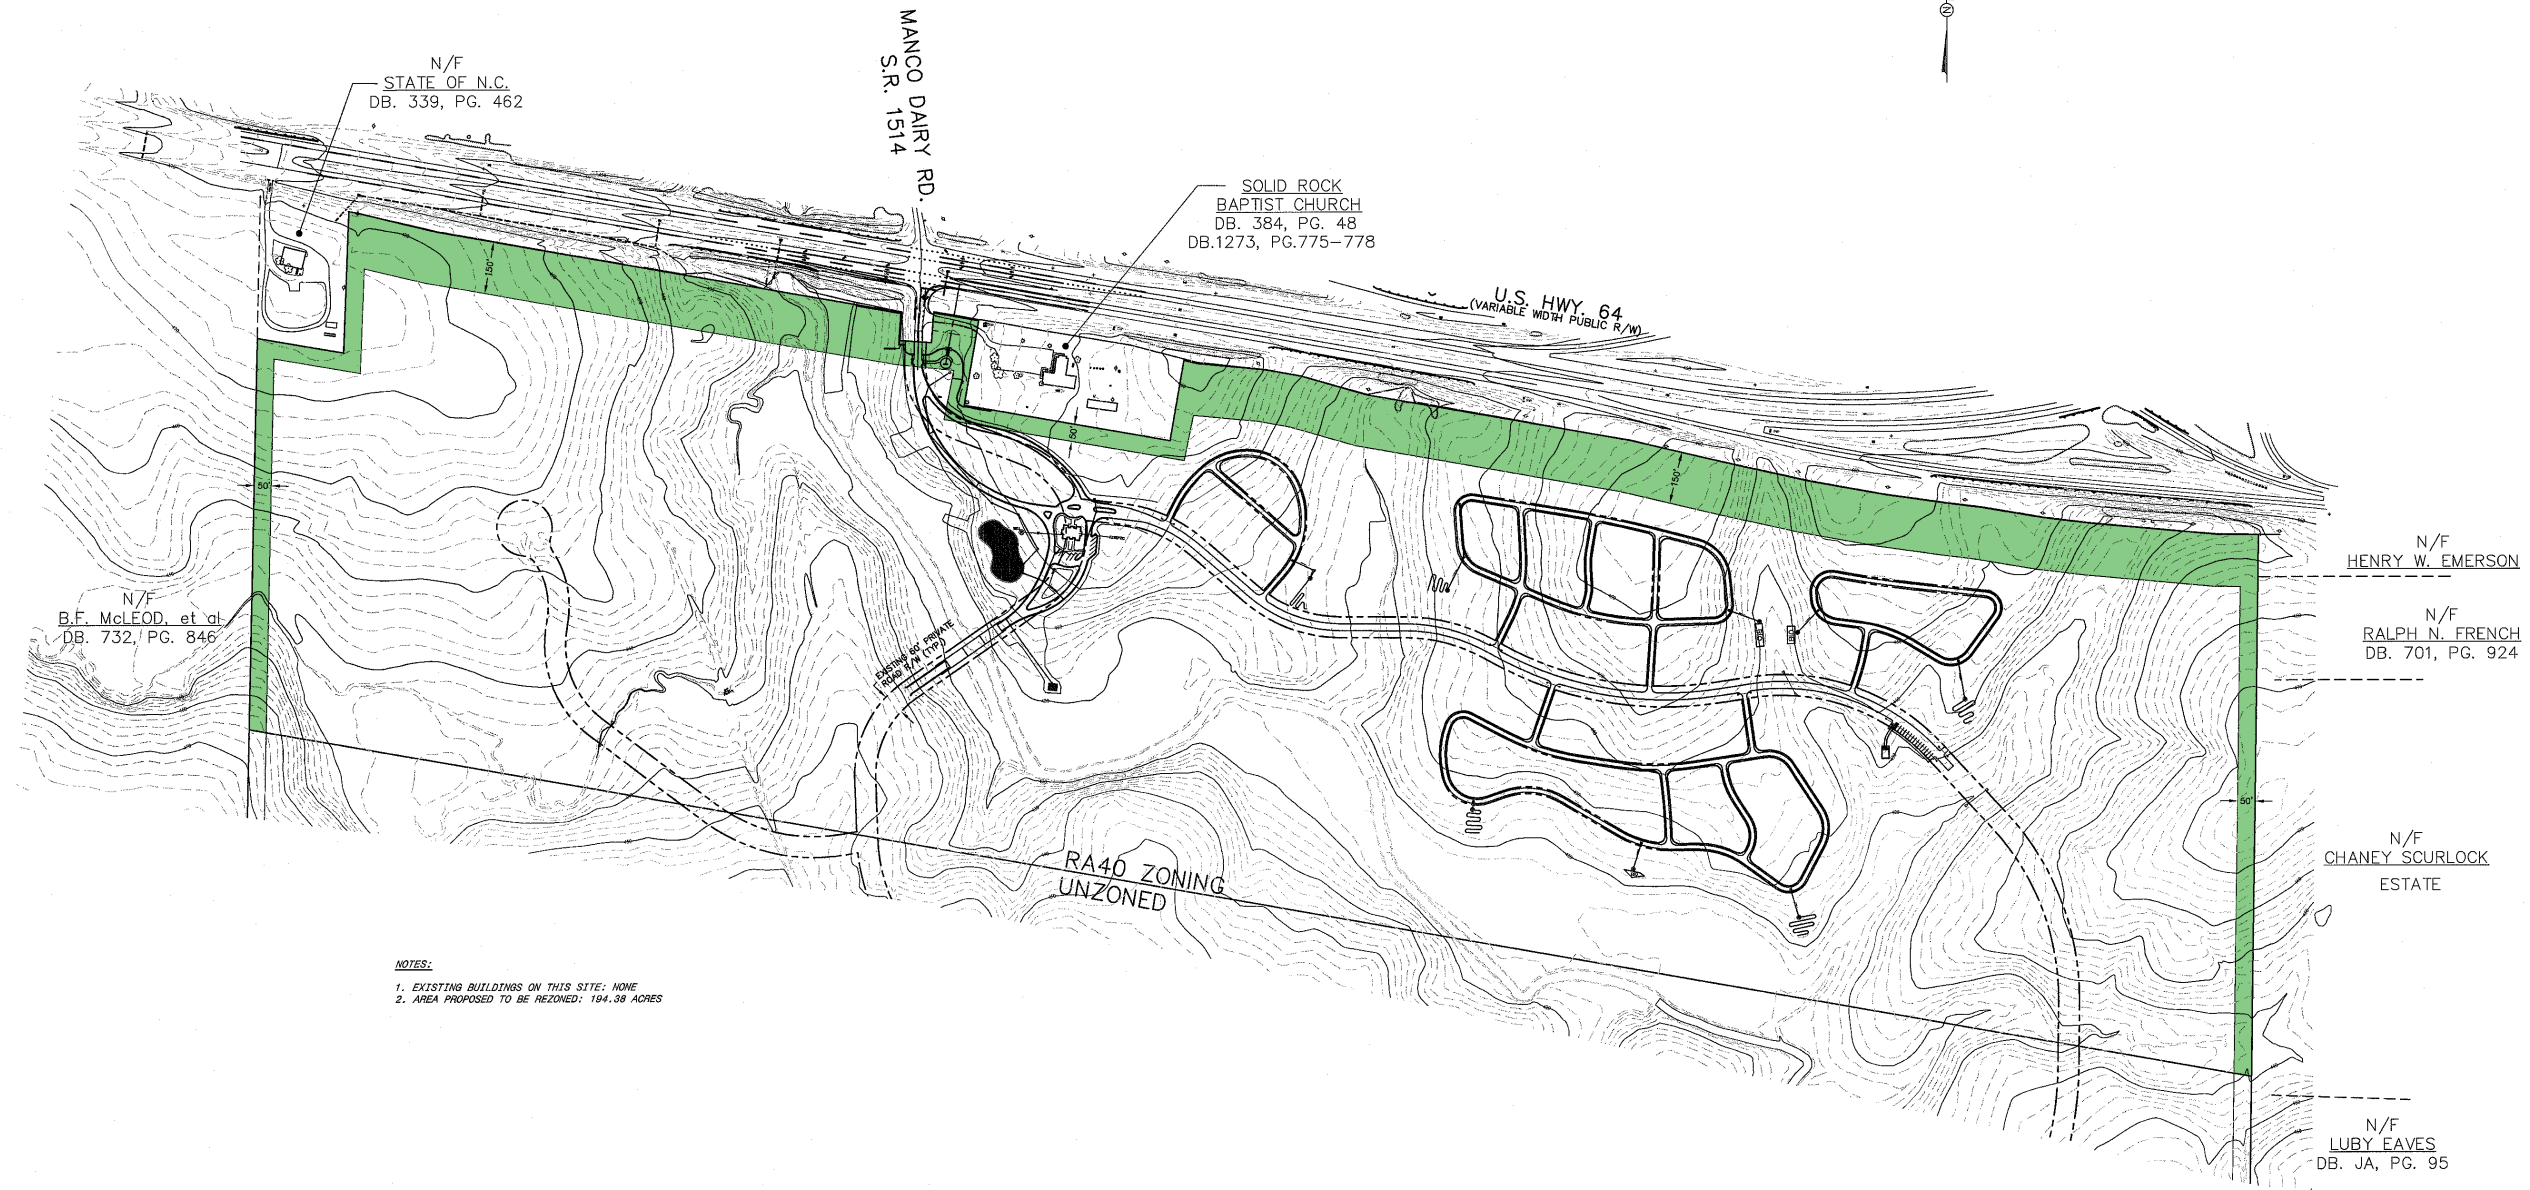

  - NOTES:
1. EXISTING BUILDINGS ON THIS SITE: NONE
 2. AREA PROPOSED TO BE REZONED: 194.38 ACRES



OWNER:
BELMEADE FARM, LLC
6208 FAYETTEVILLE RD., #104
DURHAM, N.C. 27713

ENGINEERS
PLANNERS
SURVEYORS

PHILIP
POST
&
ASSOCIATES

PRELIMINARY

TOPOGRAPHIC MAP
BELMEADE FARM CEMETERY

CENTER TOWNSHIP CHATHAM COUNTY, N.C.

SCALE 1"=200'
DRAWN BY: PWP
CHECKED BY: PWP
DATE: 09/29/2008
PROJECT NO. 010508
DRAWING NO. C237SK04

REVISIONS

SHEET C-4
OF 4