

Progress Energy Cutoff Enclosed Fixtures on 30' metal poles

Light Pattern: IESNA Type III (Oval)



Light Source: Metal Halide

Wattage: 250

Color: black

IESNA Cutoff Classification: Full Cutoff

All wall packs on buildings shall also be full cutoff.

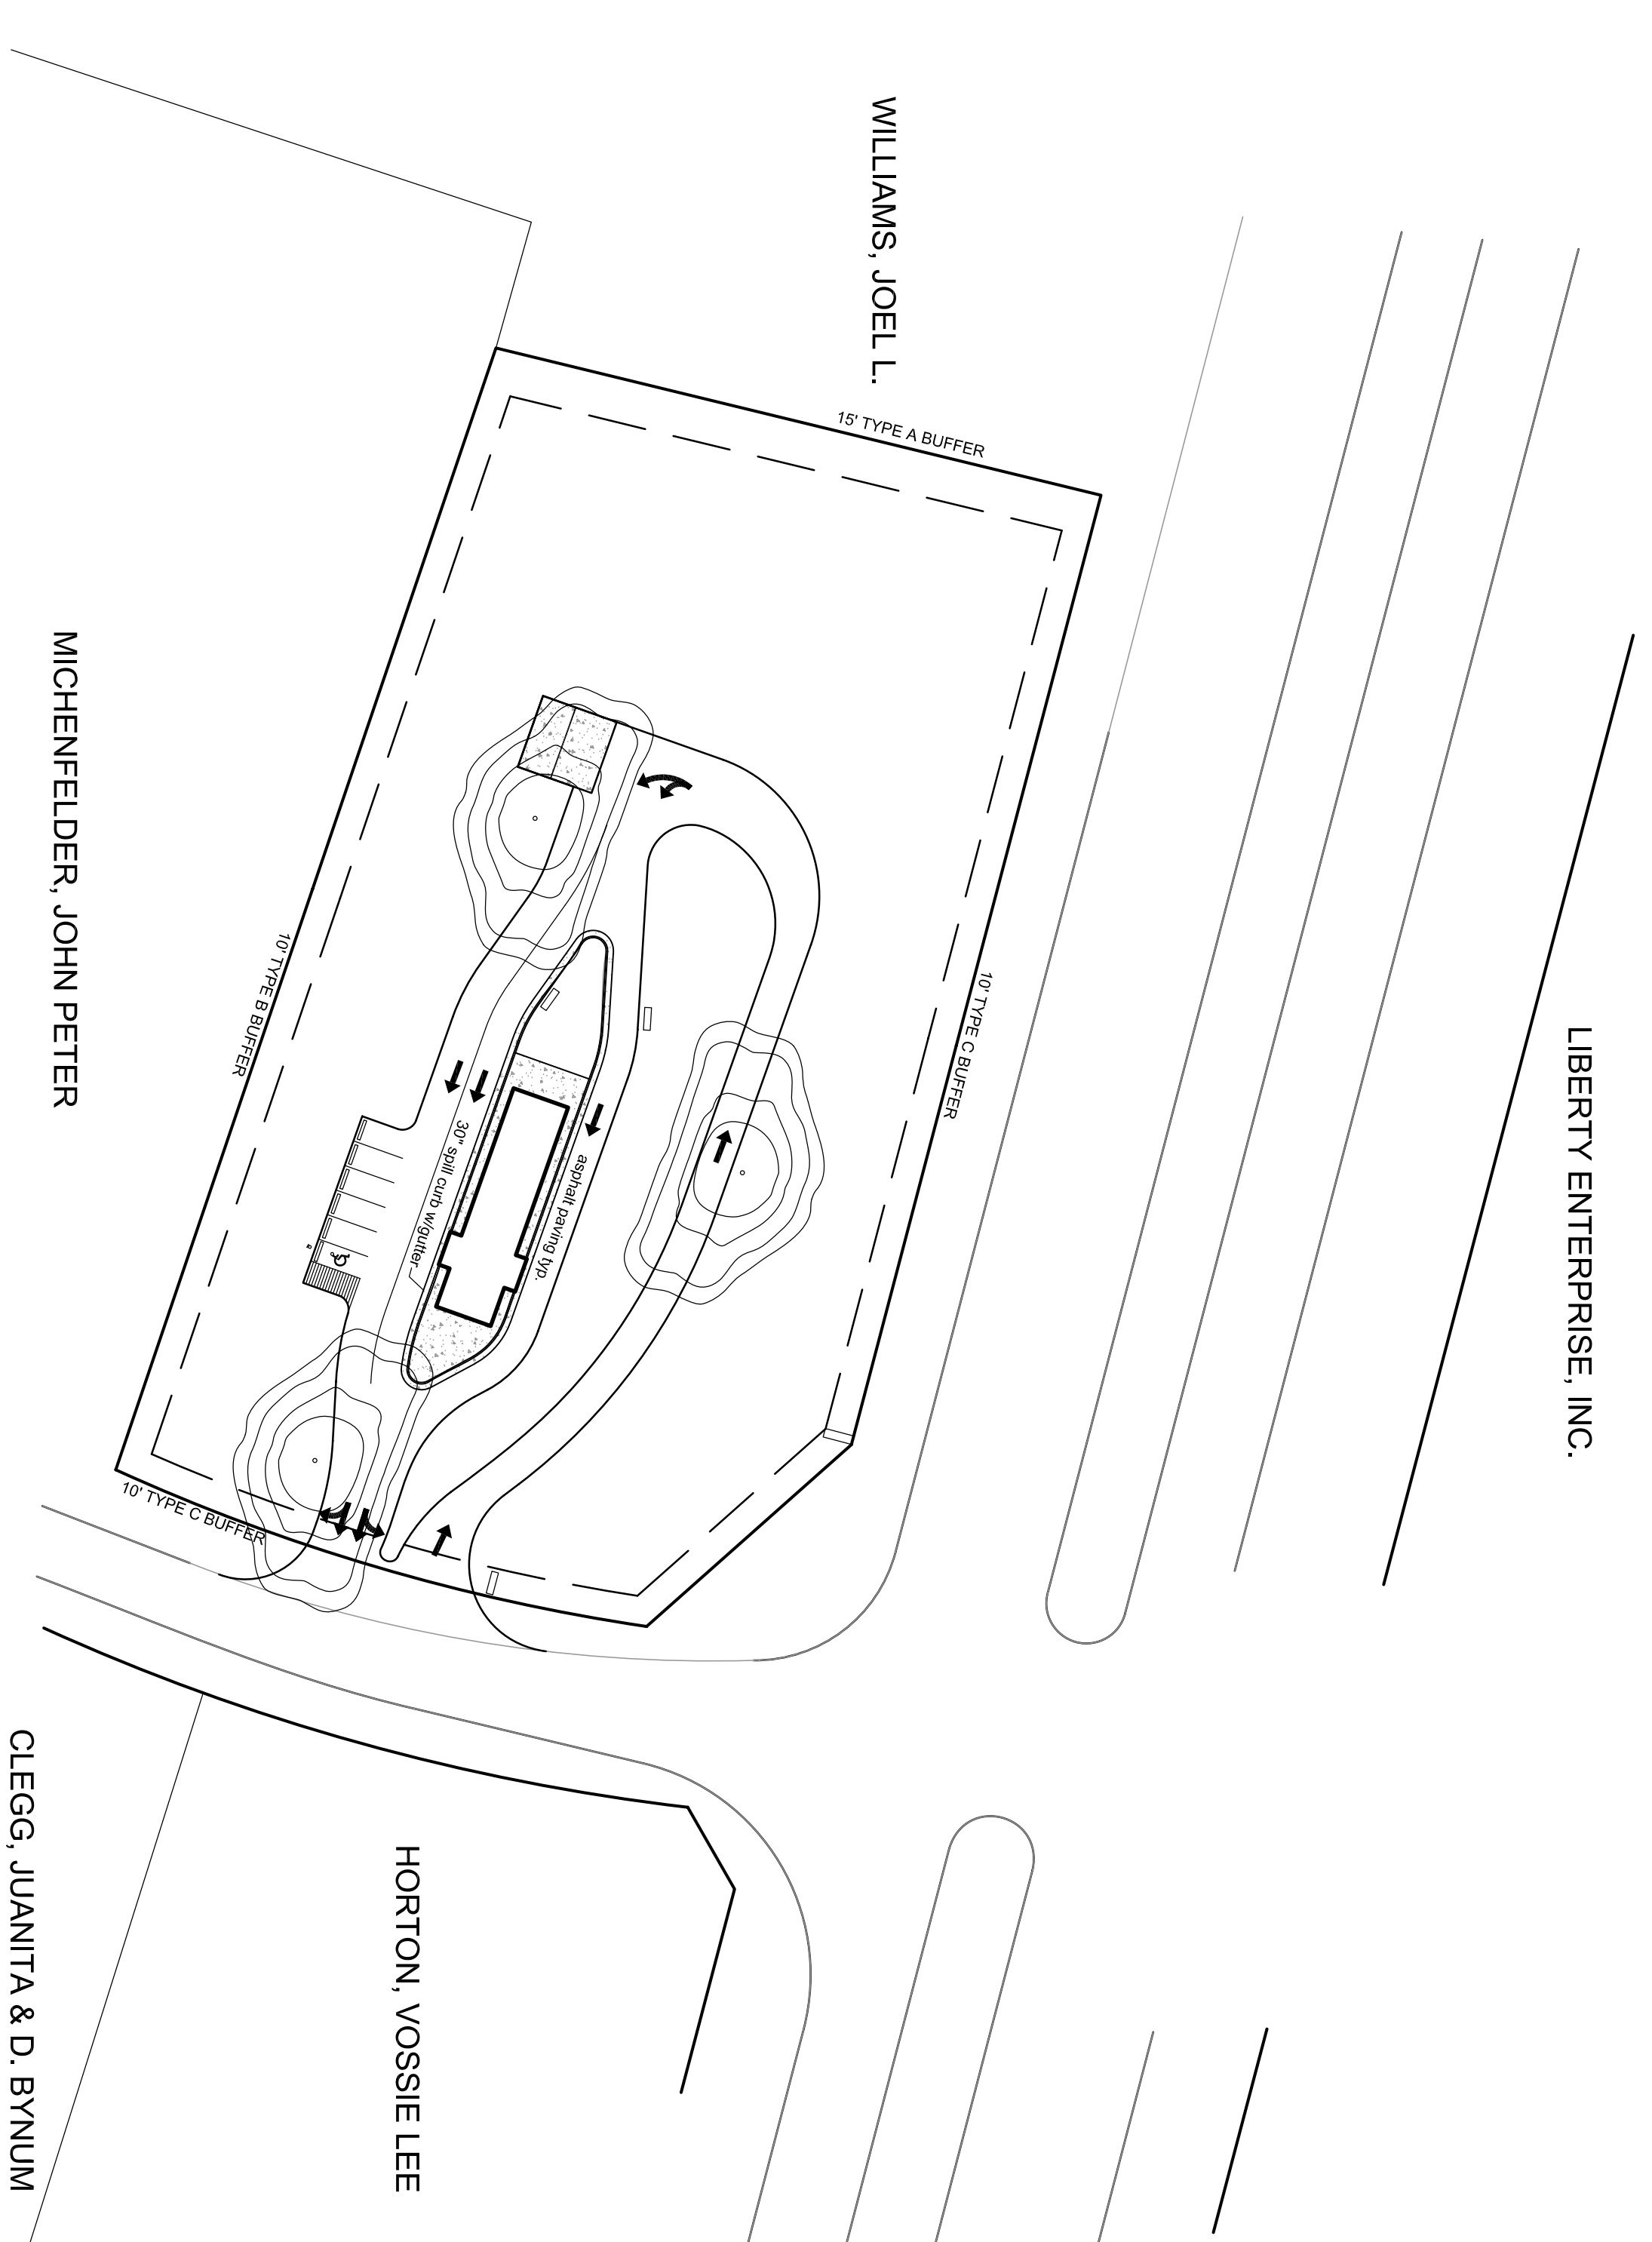
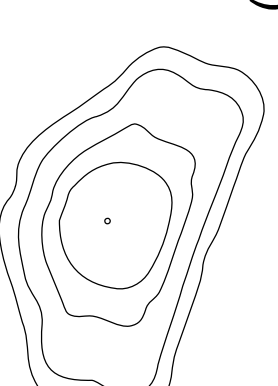


Lighting Plan

October 15, 2008



scale: 1"=50'

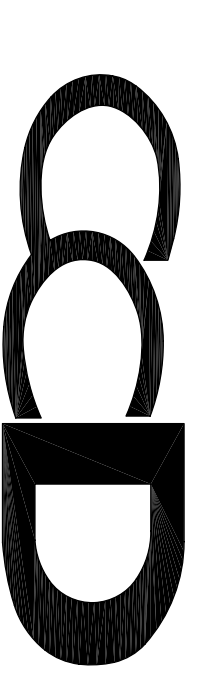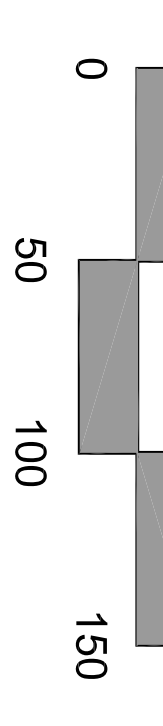

Carter Crawford DESIGN
 Land Planning Landscape Architecture Urban Design
 400 Heritage Village Lane Apex, NC 27502
 919.387.8218 voice 919.387.6548 fax

This document is an instrument of service. All rights in this document, and to the electronic files from which it was produced, including copyrights, are the sole property of Carter Crawford Design, Inc. and shall remain the property of Carter Crawford Design, Inc. for any purpose not approved by Carter Crawford Design, Inc. A-18 (07/08)