

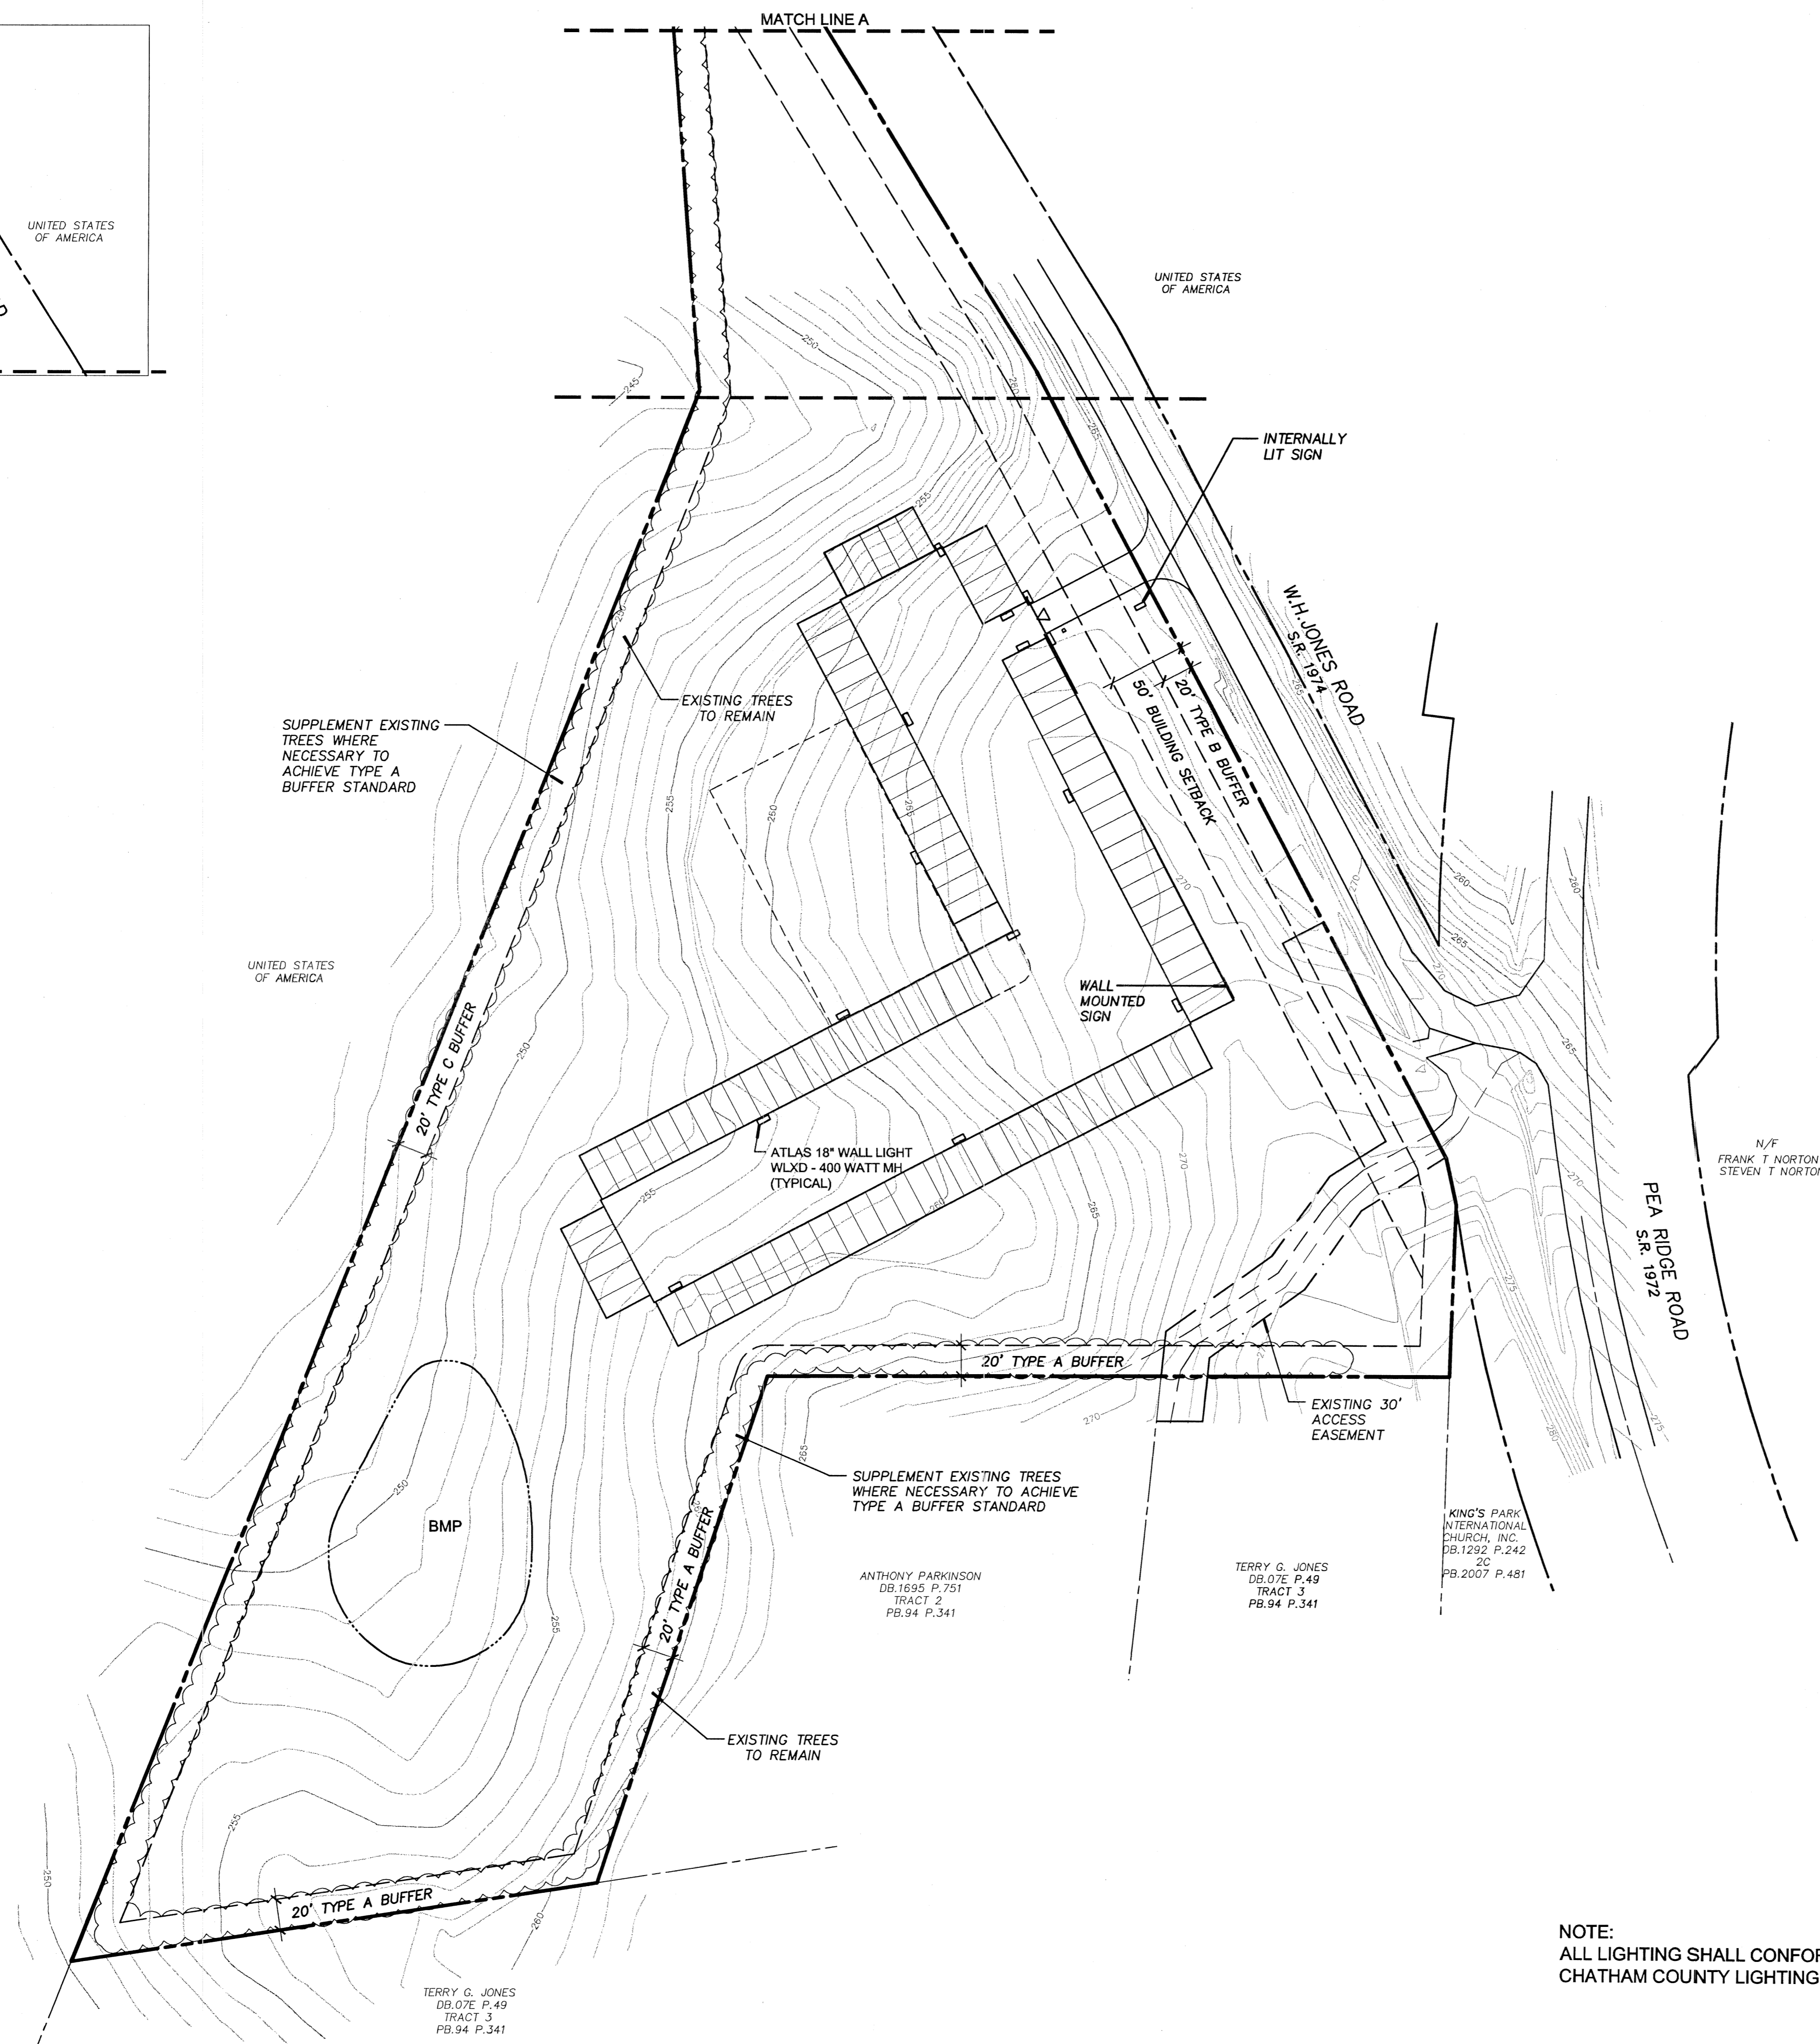


© JERRY TURNER & ASSOCIATES, INC. THIS DOCUMENT IS THE PROPERTY OF JERRY TURNER & ASSOCIATES, INC. ALL RIGHTS ARE RESERVED AND ANY POSSESSION, REPRODUCTION, OR OTHER USE OF THIS DOCUMENT WITHOUT THE PRIOR PERMISSION OF JERRY TURNER & ASSOCIATES IS EXPRESSLY PROHIBITED.

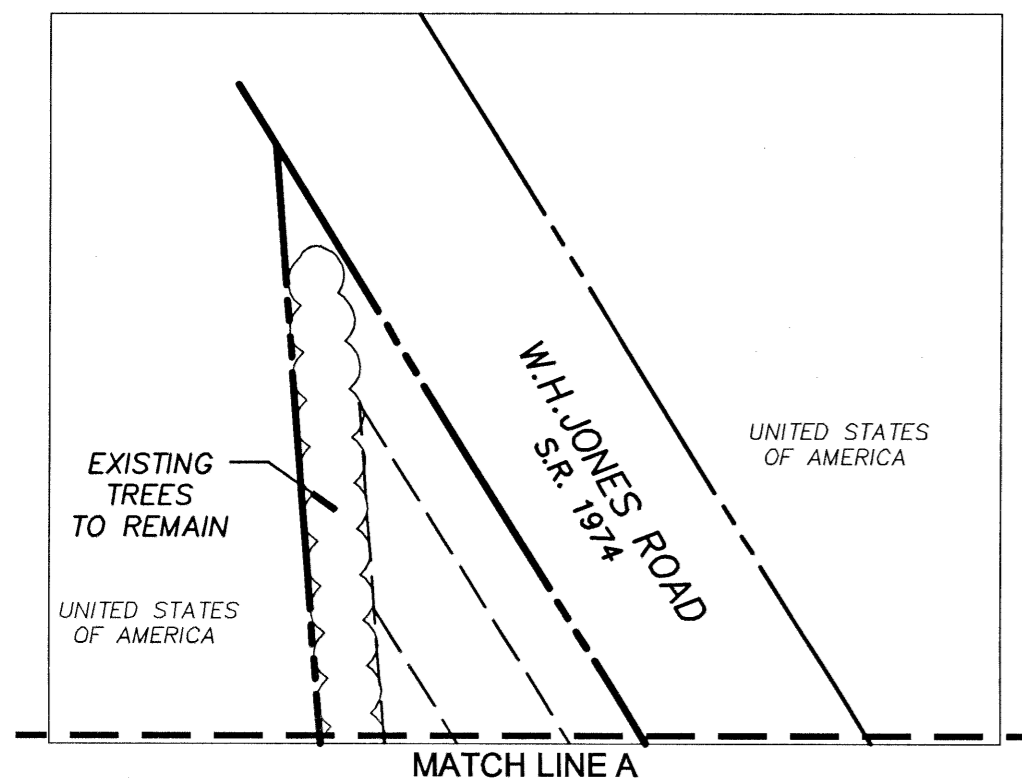

NOTE:  
ALL LIGHTING SHALL CONFORM TO THE  
CHATHAM COUNTY LIGHTING ORDINANCE.

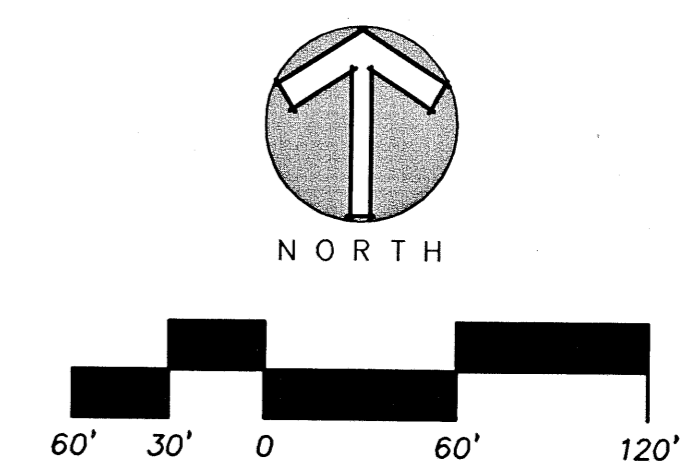

JERRY TURNER & ASSOCIATES, INC.

Landscape Architecture  
Land Planning  
Environmental Design

905 Jones Franklin Road  
Raleigh, North Carolina 27606  
(919) 851-7150 fax. (919) 851-7547

277 S.E. 5th Avenue  
Delray Beach, Florida 33483  
(561) 276-0453 fax. (561) 272-7593

PROJECT

# THE EXTRA GARAGE III SELF-STORAGE CENTER

CHATHAM COUNTY, NC

OWNER/DEVELOPER:  
WALTER LEWIS

REVISIONS

DRAWN	CHECKED
RT	WH
SCALE	DATE
1"=60'	1/3/14
TITLE	

## OVERALL LANDSCAPE & LIGHTING PLAN

FILE NO. \_\_\_\_\_ JOB NO. \_\_\_\_\_

SEAL \_\_\_\_\_ SHEET NO. \_\_\_\_\_